

GENERAL LEGEND

SITE LOCATION

EXISTING 110V GALVANY DUBLIN MOTORWAY



NOTES

1. FIELDED DIMENSIONS ONLY TO BE TAKEN FROM THIS DRAWING
2. ALL DRAWINGS TO BE CHECKED BY THE CONTRACTOR ON SITE
3. ENGINEER TO BE INFORMED BY THE CONTRACTOR OF ANY DISCREPANCIES BEFORE ANY WORK COMMENCES
4. ALL LEVELS SHOWN RELATE TO ORDNANCE SURVEY DATUM AT MAIN HEAD
5. OS DISCOVERY SHEET NOS. 1220, 1420

Rev	Date	Description	By	Chkd
A	17/06/19	Final Issue	JK	BR

Client: **Mr. Sean Curran**

Project: **Pollboy Waste Transfer station**

Title: **Regional Site Location Map**

Scale @ A1: 1:25 000 @ A3: 1:50 000
 Prepared By: JK
 Checked: BR
 Date: June 2019
 Project Director: Michael McDonnell
 Drawing Status: Waste Licence Application



TOBIN Consulting Engineers,
 Fairgreen House, Fairgreen Road,
 Galway, Ireland.
 Tel: +353 (0)91-565211
 Fax: +353 (0)91-565208
 email: galway@tobin.ie
 www.tobin.ie

Drawing No: **7526-2440** Revisions: **A**


SITE ENTRANCE

SITE NOTICE LOCATIONS
(see also drg 7526-2450)

SITE BOUNDARY
OUTLINED RED

OWNERSHIP LINE
Pollboy Civic Amenity Facility

Existing Pollboy Landfill Facility

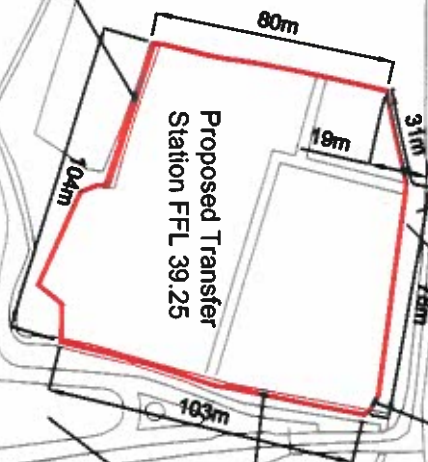

- NOTE:
1. FIGURED DIMENSIONS ONLY TO BE TAKEN FROM THIS DRAWING
 2. ALL DRAWINGS TO BE CHECKED BY THE CONTRACTOR ON SITE
 3. ENGINEERS/EMPLOYERS REPRESENTATIVE, AS APPROPRIATE, TO BE INFORMED BY THE CONTRACTOR OF ANY DISCREPANCIES BEFORE ANY WORK COMMENCES
 4. THE CONTRACTOR SHALL UNDERTAKE A THOROUGH CHECK FOR THE ACTUAL LOCATION OF ALL SERVICES/UTILITIES, ABOVE AND BELOW GROUND, BEFORE ANY WORK COMMENCES
 5. ALL LEVELS SHOWN RELATE TO ORDNANCE SURVEY DATUM AT MALIN HEAD

Rev	Date	Description	By	Chkd
1	24.06.19	Final Issue	JK	BR

Client:
Mr. Sean Curran

Project:
Pollboy
Waste Transfer Station

Title:
Site Location and Site Boundary


Scale: @ A3:1:2500 @ A1: 1:1250

Prepared by: JK
Checked: BR
Date: June 2019

Project Director: Michael McDonnell
Drawing Status: Waste Licence Application

TOBIN
Patrick J. Tobin & Co. Ltd.
TOBIN Consulting Engineers,
Flaggreen House, Falgreen Road,
Galway, Ireland.
Tel: +353-(0)91-866211
Fax: +353-(0)91-866388
e-mail: galway@tobin.ie
www.tobin.ie

Revision:
Drawing No: 7526-2441
A

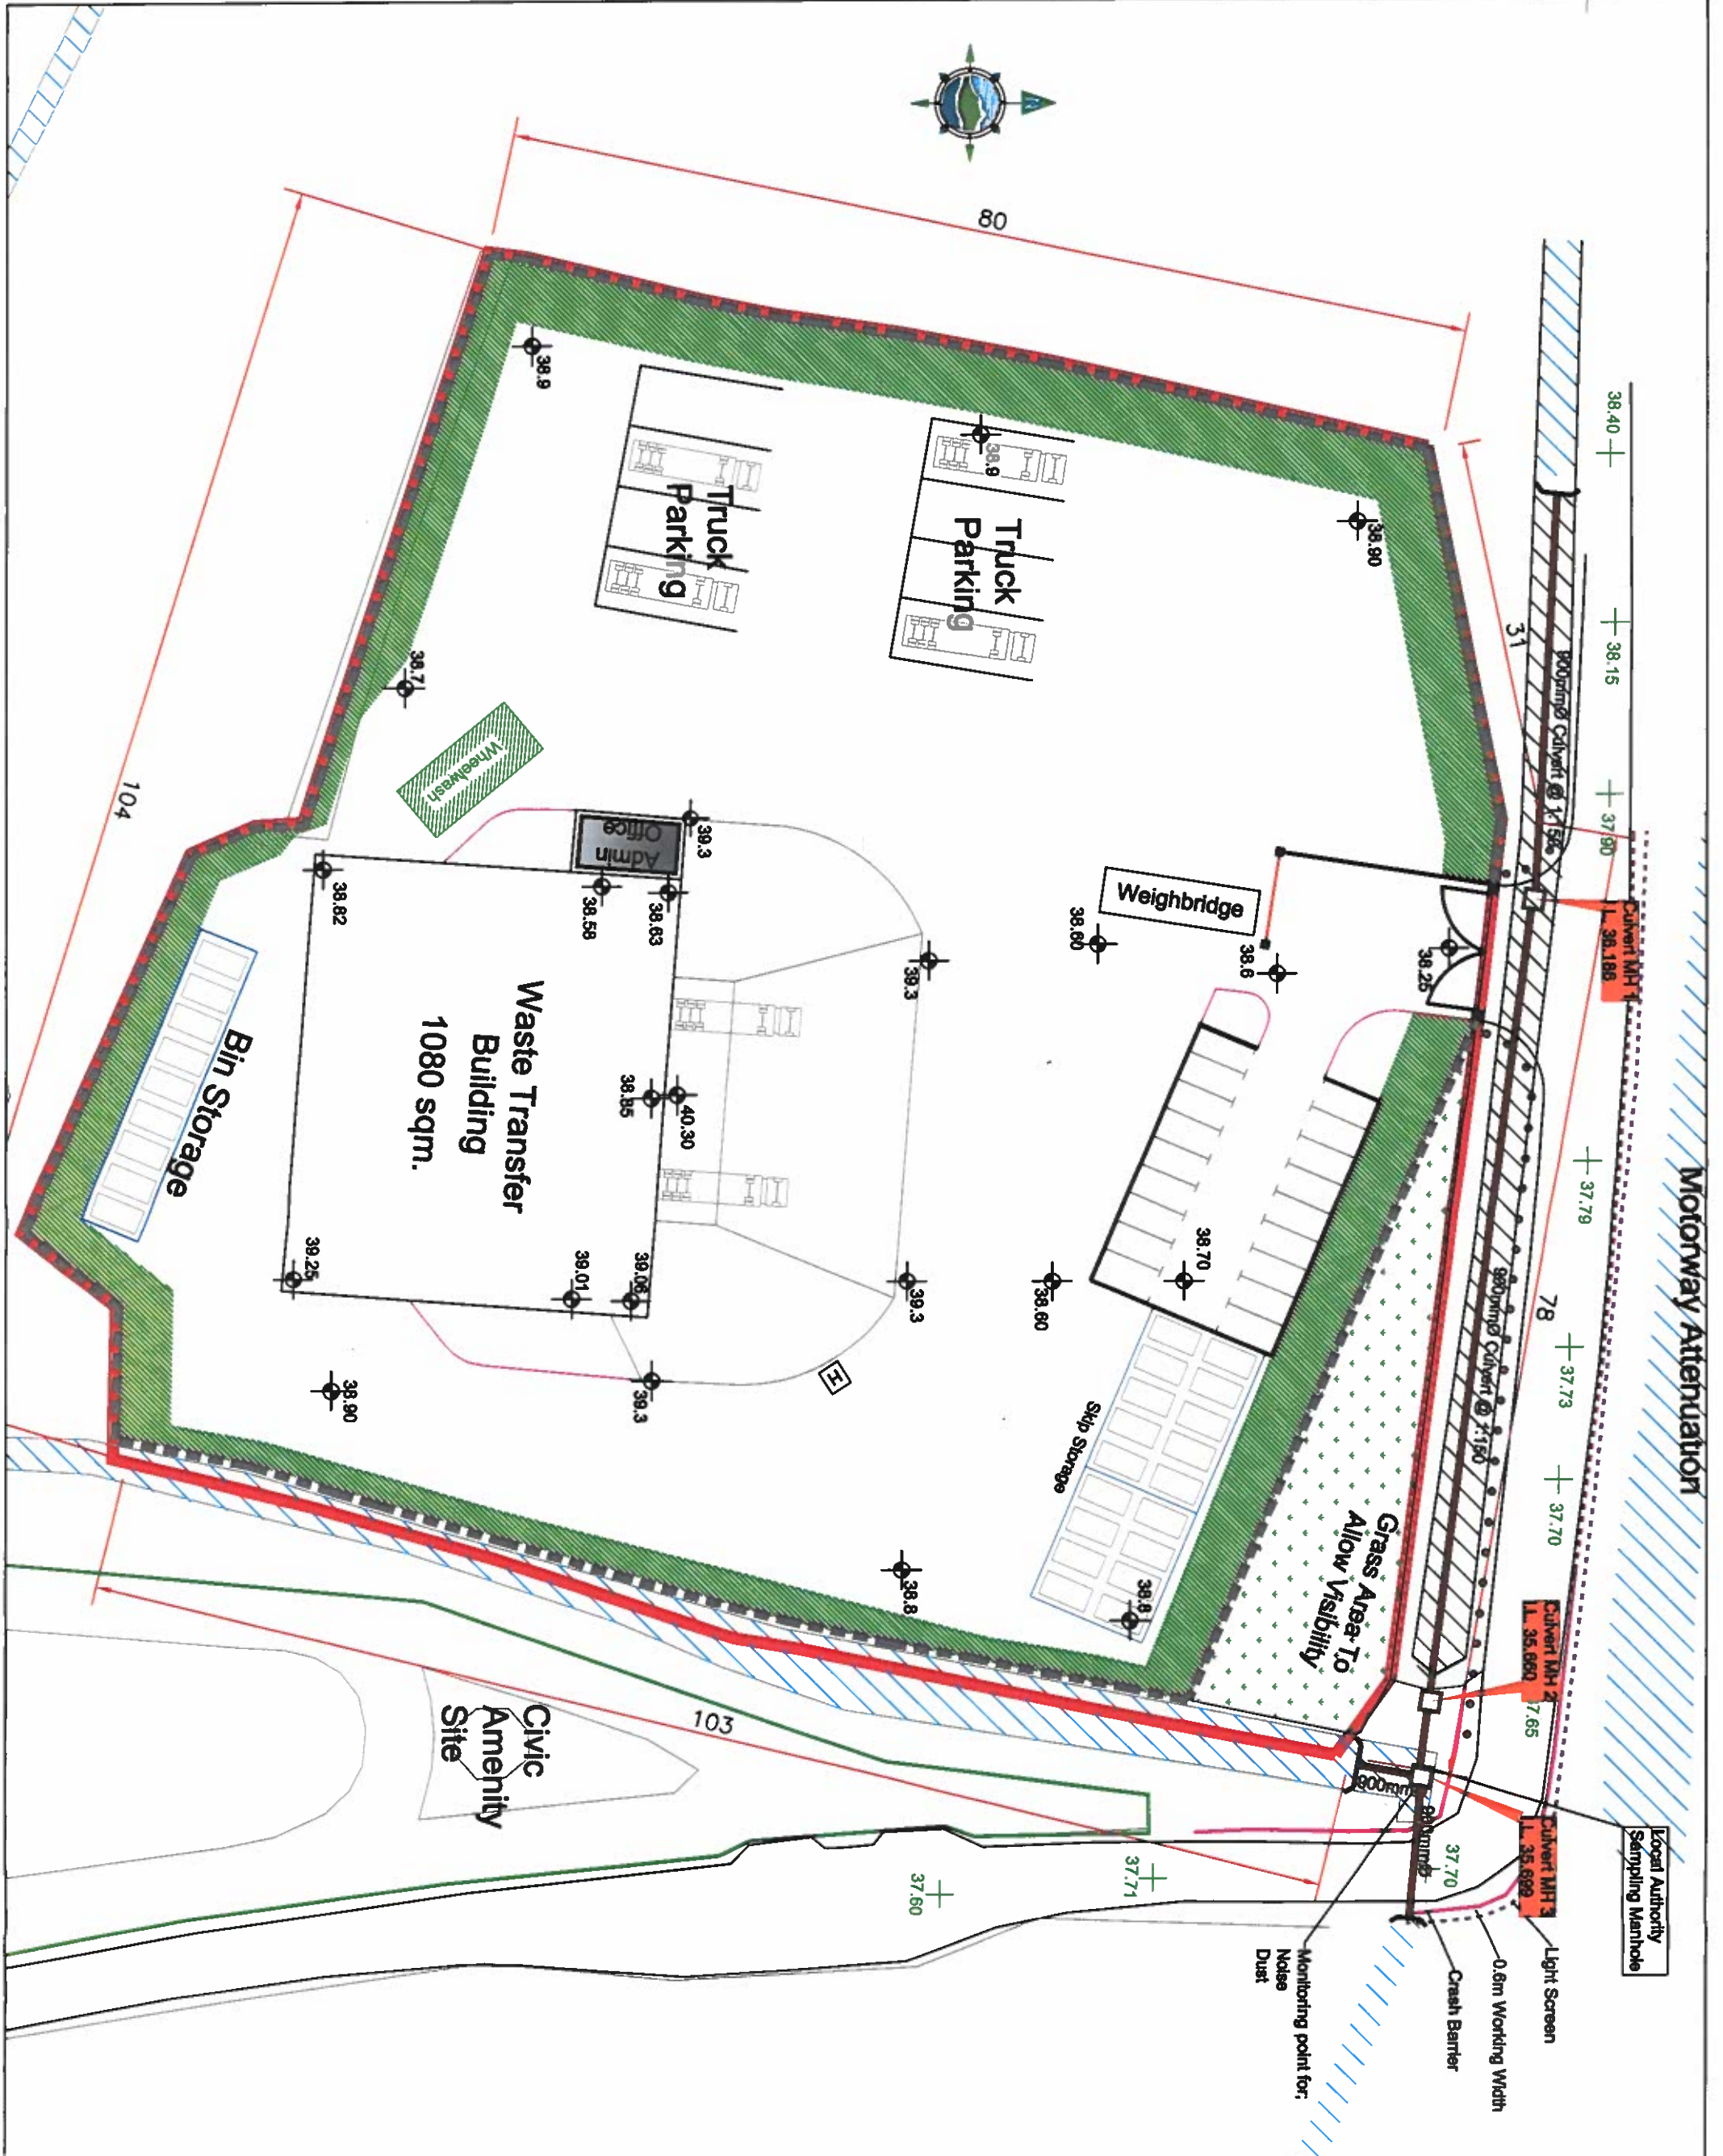

Motorway Attenuation

Local Authority
Sampling Manhole

- Legend**
- Planted Screening:
 - Existing Drainage:
 - Site Boundary:
 - 2m High Boundary Wall:
 - Proposed 4m High Vehicle Headlight Screen:
 - Proposed Crash Barrier:
 - Existing Crash Barrier:
 - Motorway Timber Fence:
 - Timber Bolands (900x400x1.00M) (SCRS):
 - Civic Amenity Boundary:
 - Wheekwash:

- NOTES:**
1. FIGURED DIMENSIONS ONLY TO BE TAKEN FROM THIS DRAWING.
 2. ALL DRAWINGS TO BE CHECKED BY THE CONTRACTOR ON SITE.
 3. ENGINEERS/EMPLOYERS REPRESENTATIVE AS APPROPRIATE, TO BE INFORMED BY THE CONTRACTOR OF ANY DISCREPANCIES BEFORE ANY WORK COMMENCES.
 4. THE CONTRACTOR SHALL UNDERTAKE A THOROUGH CHECK FOR THE ACTUAL LOCATION OF ALL SERVICES/UTILITIES ABOVE AND BELOW GROUND, BEFORE ANY WORK COMMENCES.
 5. ALL LEVELS SHOWN RELATE TO ORDNANCE SURVEY DATUM AT MALIN HEAD.

Rev	Date	Description	By	CHK
1	07/06/2019	ISSUED FOR TENDERING	MK	BH

Client: MR. SEAN CURRAN

Project: POLLBOY WASTE TRANSFER STATION

Title: SITE LAYOUT

Scale @ A3: 1:1000 @A1: 1:500

Prepared by: MK
Checked: BH
Date: June 2019


Project Director: J.P. Kelly
Drawing Status: Waste Licence Application

TOBIN
Pollboy Waste Transfer Station

TOBIN Consulting Engineers,
Fairgreen House, Fairgreen Road,
Galway, Ireland.
Tel: +353-(0)91-566211
Fax: +353-(0)91-566208
email: galway@tobin.ie
www.tobin.ie

Drawing No: 7526-2442
Revision: A

Motorway Attenuation

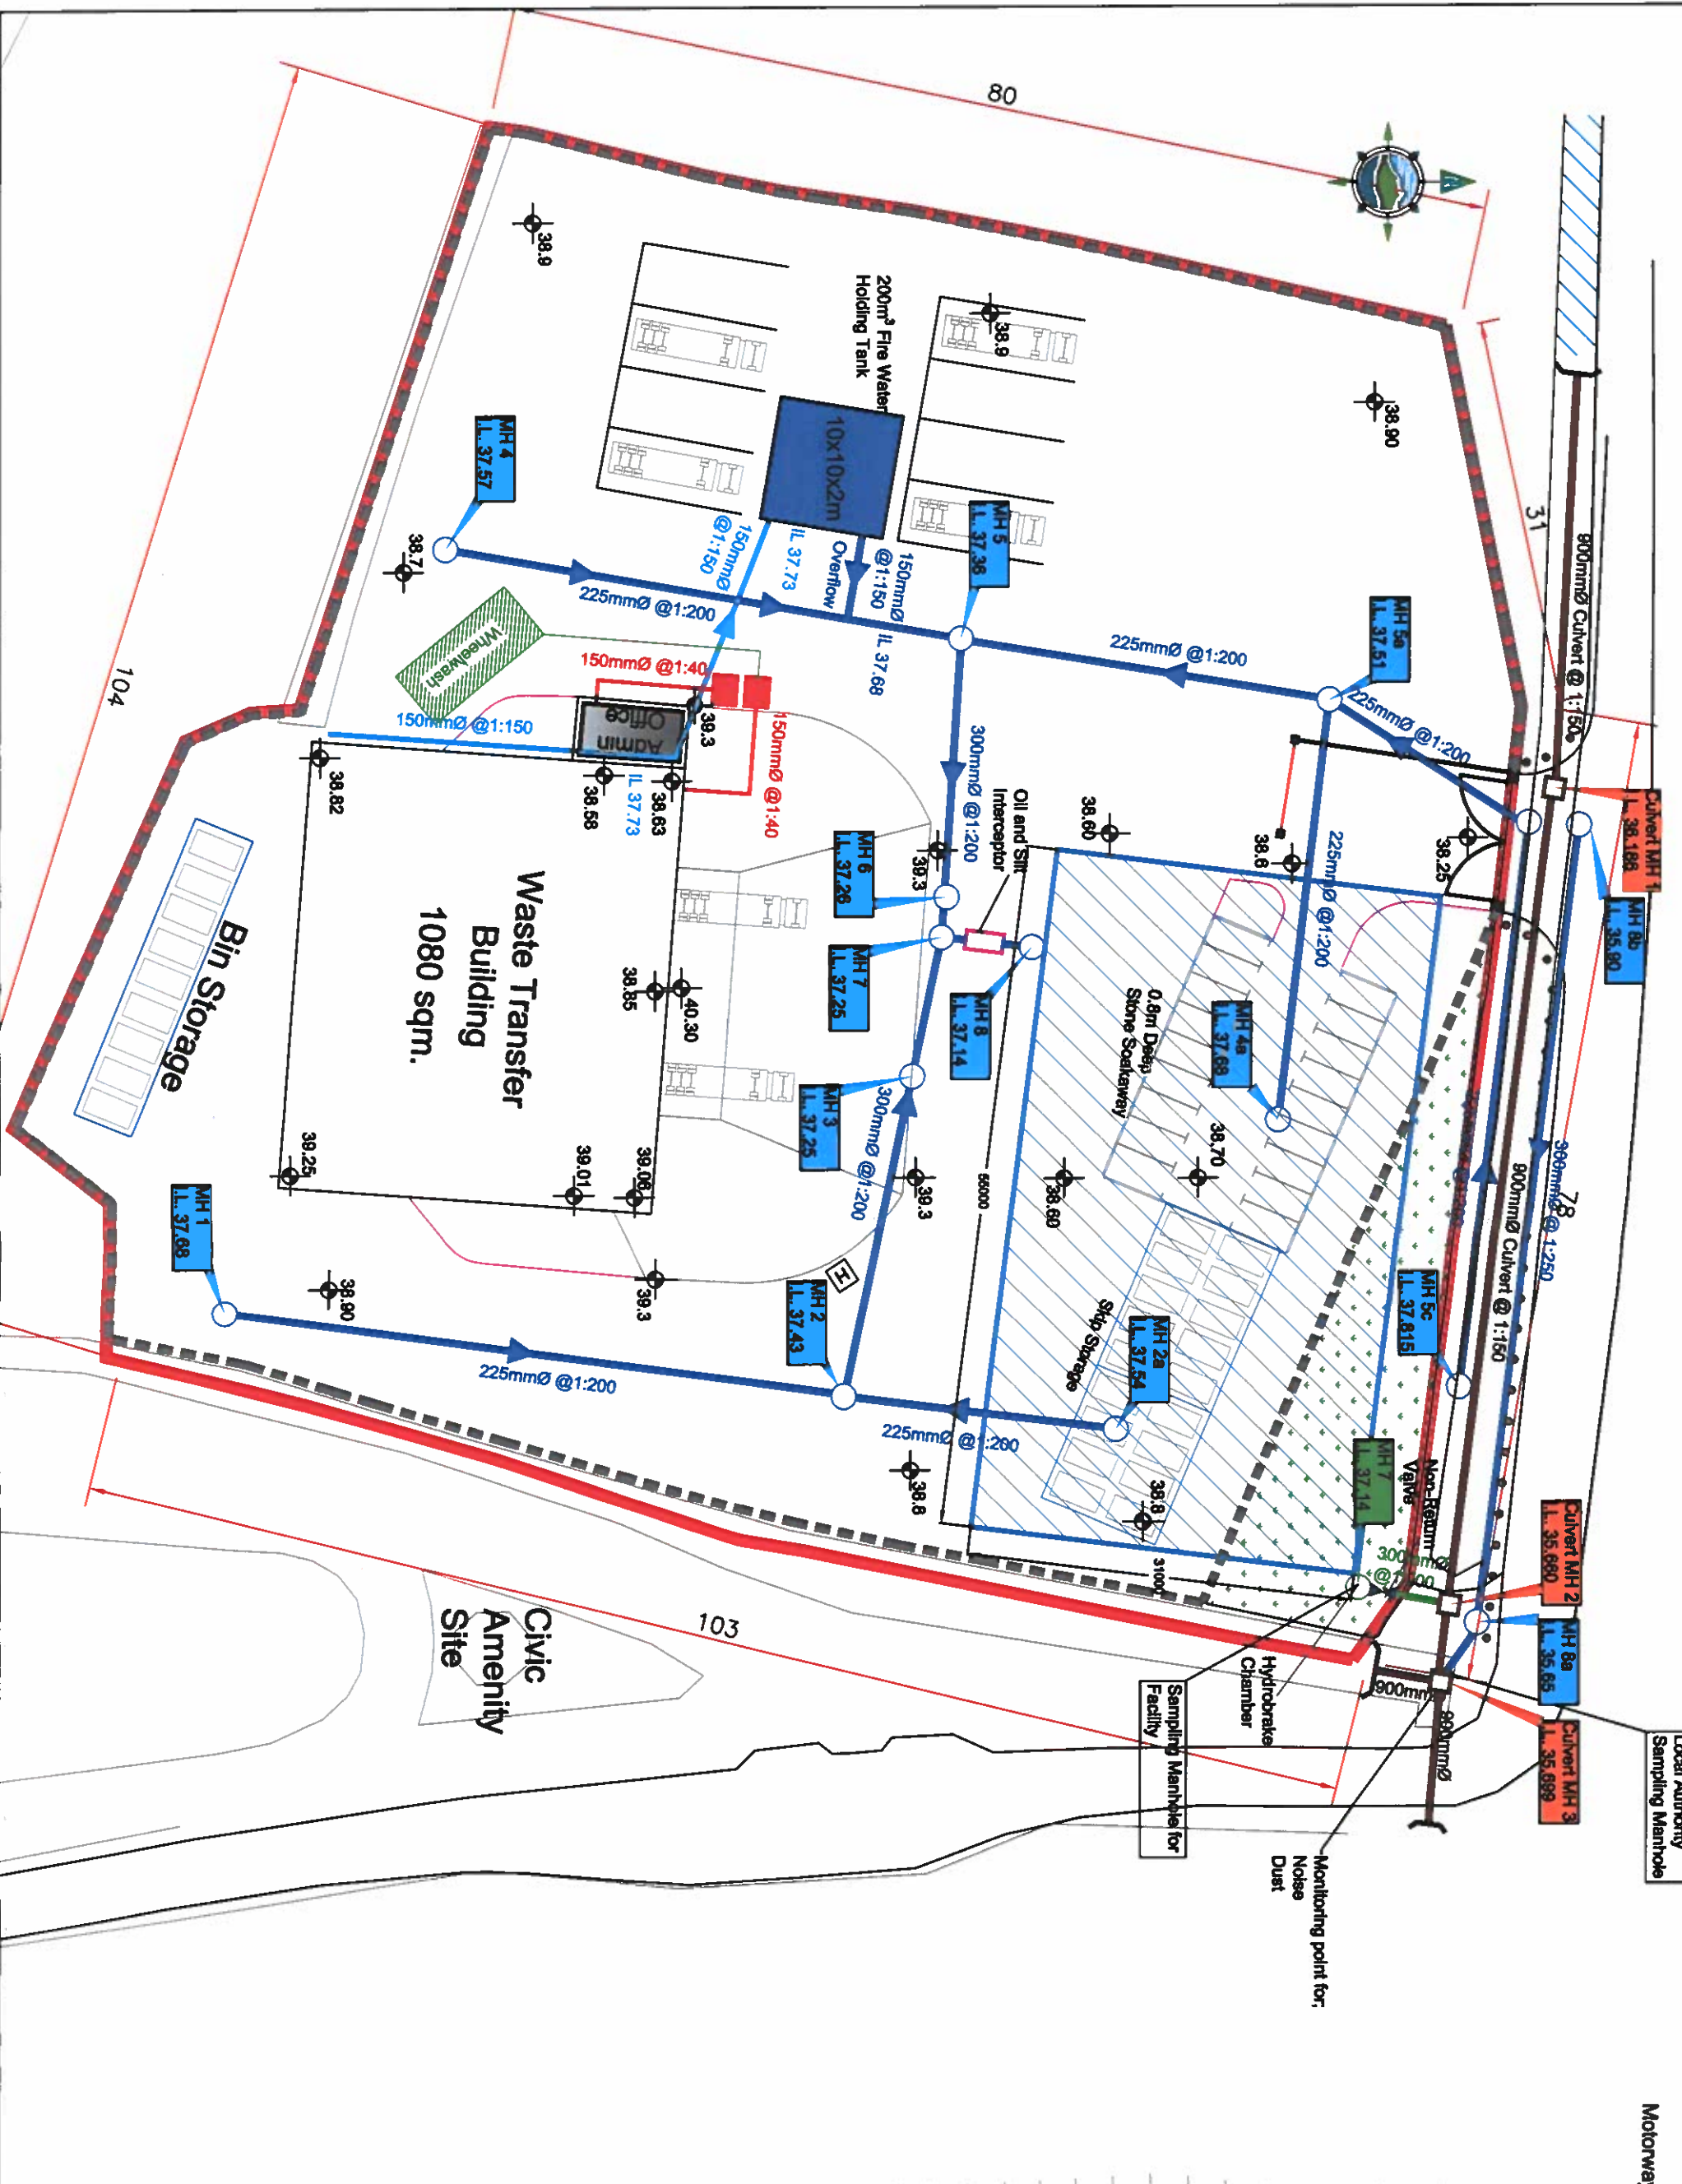

Local Authority
Sampling Manhole

Motorway F

Monitoring point for:
Noise
Dust

Sampling Manhole for
Facility

Hydrobake
Chamber

Non-Return
Valve

Skip Storage

0.9m Deep
Stone Soakaway

Oil and Silt
Interceptor

200m³ Fire Water
Holding Tank

10x10x2m
Overflow

Admin
Office

Bin Storage

Waste Transfer
Building
1080 sqm.

Civic
Amenity
Site

Legend

- Proposed Storm
- Sewer
- Proposed Storm
- Outfall
- Proposed Fire Water Tank Feed
- Proposed Foul Sewer
- Proposed Storm Manhole
- Road Gully
- Lined Attenuation Area
- Oil Interceptor
- Proposed Sewage Holding Tank and Floor Wash Tank
- 2m High Boundary Wall
- Wheelwash

NOTES:

1. DIMENSIONS ONLY TO BE TAKEN FROM THE FINISHED SURFACE.
2. ALL DRAWINGS TO BE CHECKED BY THE CONTRACTOR ON SITE.
3. ENGINEERS/OVERSEERS REPRESENTATIVE, AS APPROPRIATE, TO BE INFORMED BY THE CONTRACTOR OF ANY DISCREPANCIES BEFORE ANY WORK COMMENCES.
4. THE CONTRACTOR SHALL UNDERTAKE A THOROUGH CHECK FOR THE ACTUAL LOCATION OF ALL SERVICES/UTILITIES, ABOVE AND BELOW GROUND, BEFORE ANY WORK COMMENCES.
5. ALL LEVELS SHOWN RELATE TO ORDNANCE SURVEY DATUM AT MAIN HEAD.

No.	Date	Description	By	Chk
1	08/06/2019	ISSUED FOR TENDERING	BH	BM

Client: MR. SEAN CURRAN

Project: POLLBOY
WASTE TRANSFER STATION

Title: DRAINAGE LAYOUT


Scale @ A3: 1:500 @ A1: 1:250
Prepared by: MK
Checked: BH
Date: June 2019
Project Director: J.P. Kelly
Drawing Status: Waste Licence Application



TOBIN Consulting Engineers,
Faldrum House, Faldrum Road,
Galway, Ireland.
Tel: +353-(0)91-566211
Fax: +353-(0)91-566386
e-mail: galway@tobin.ie
www.tobin.ie

Drawing No: 7526-2443
Revision: A

IVULIWAY AMENIATUUI

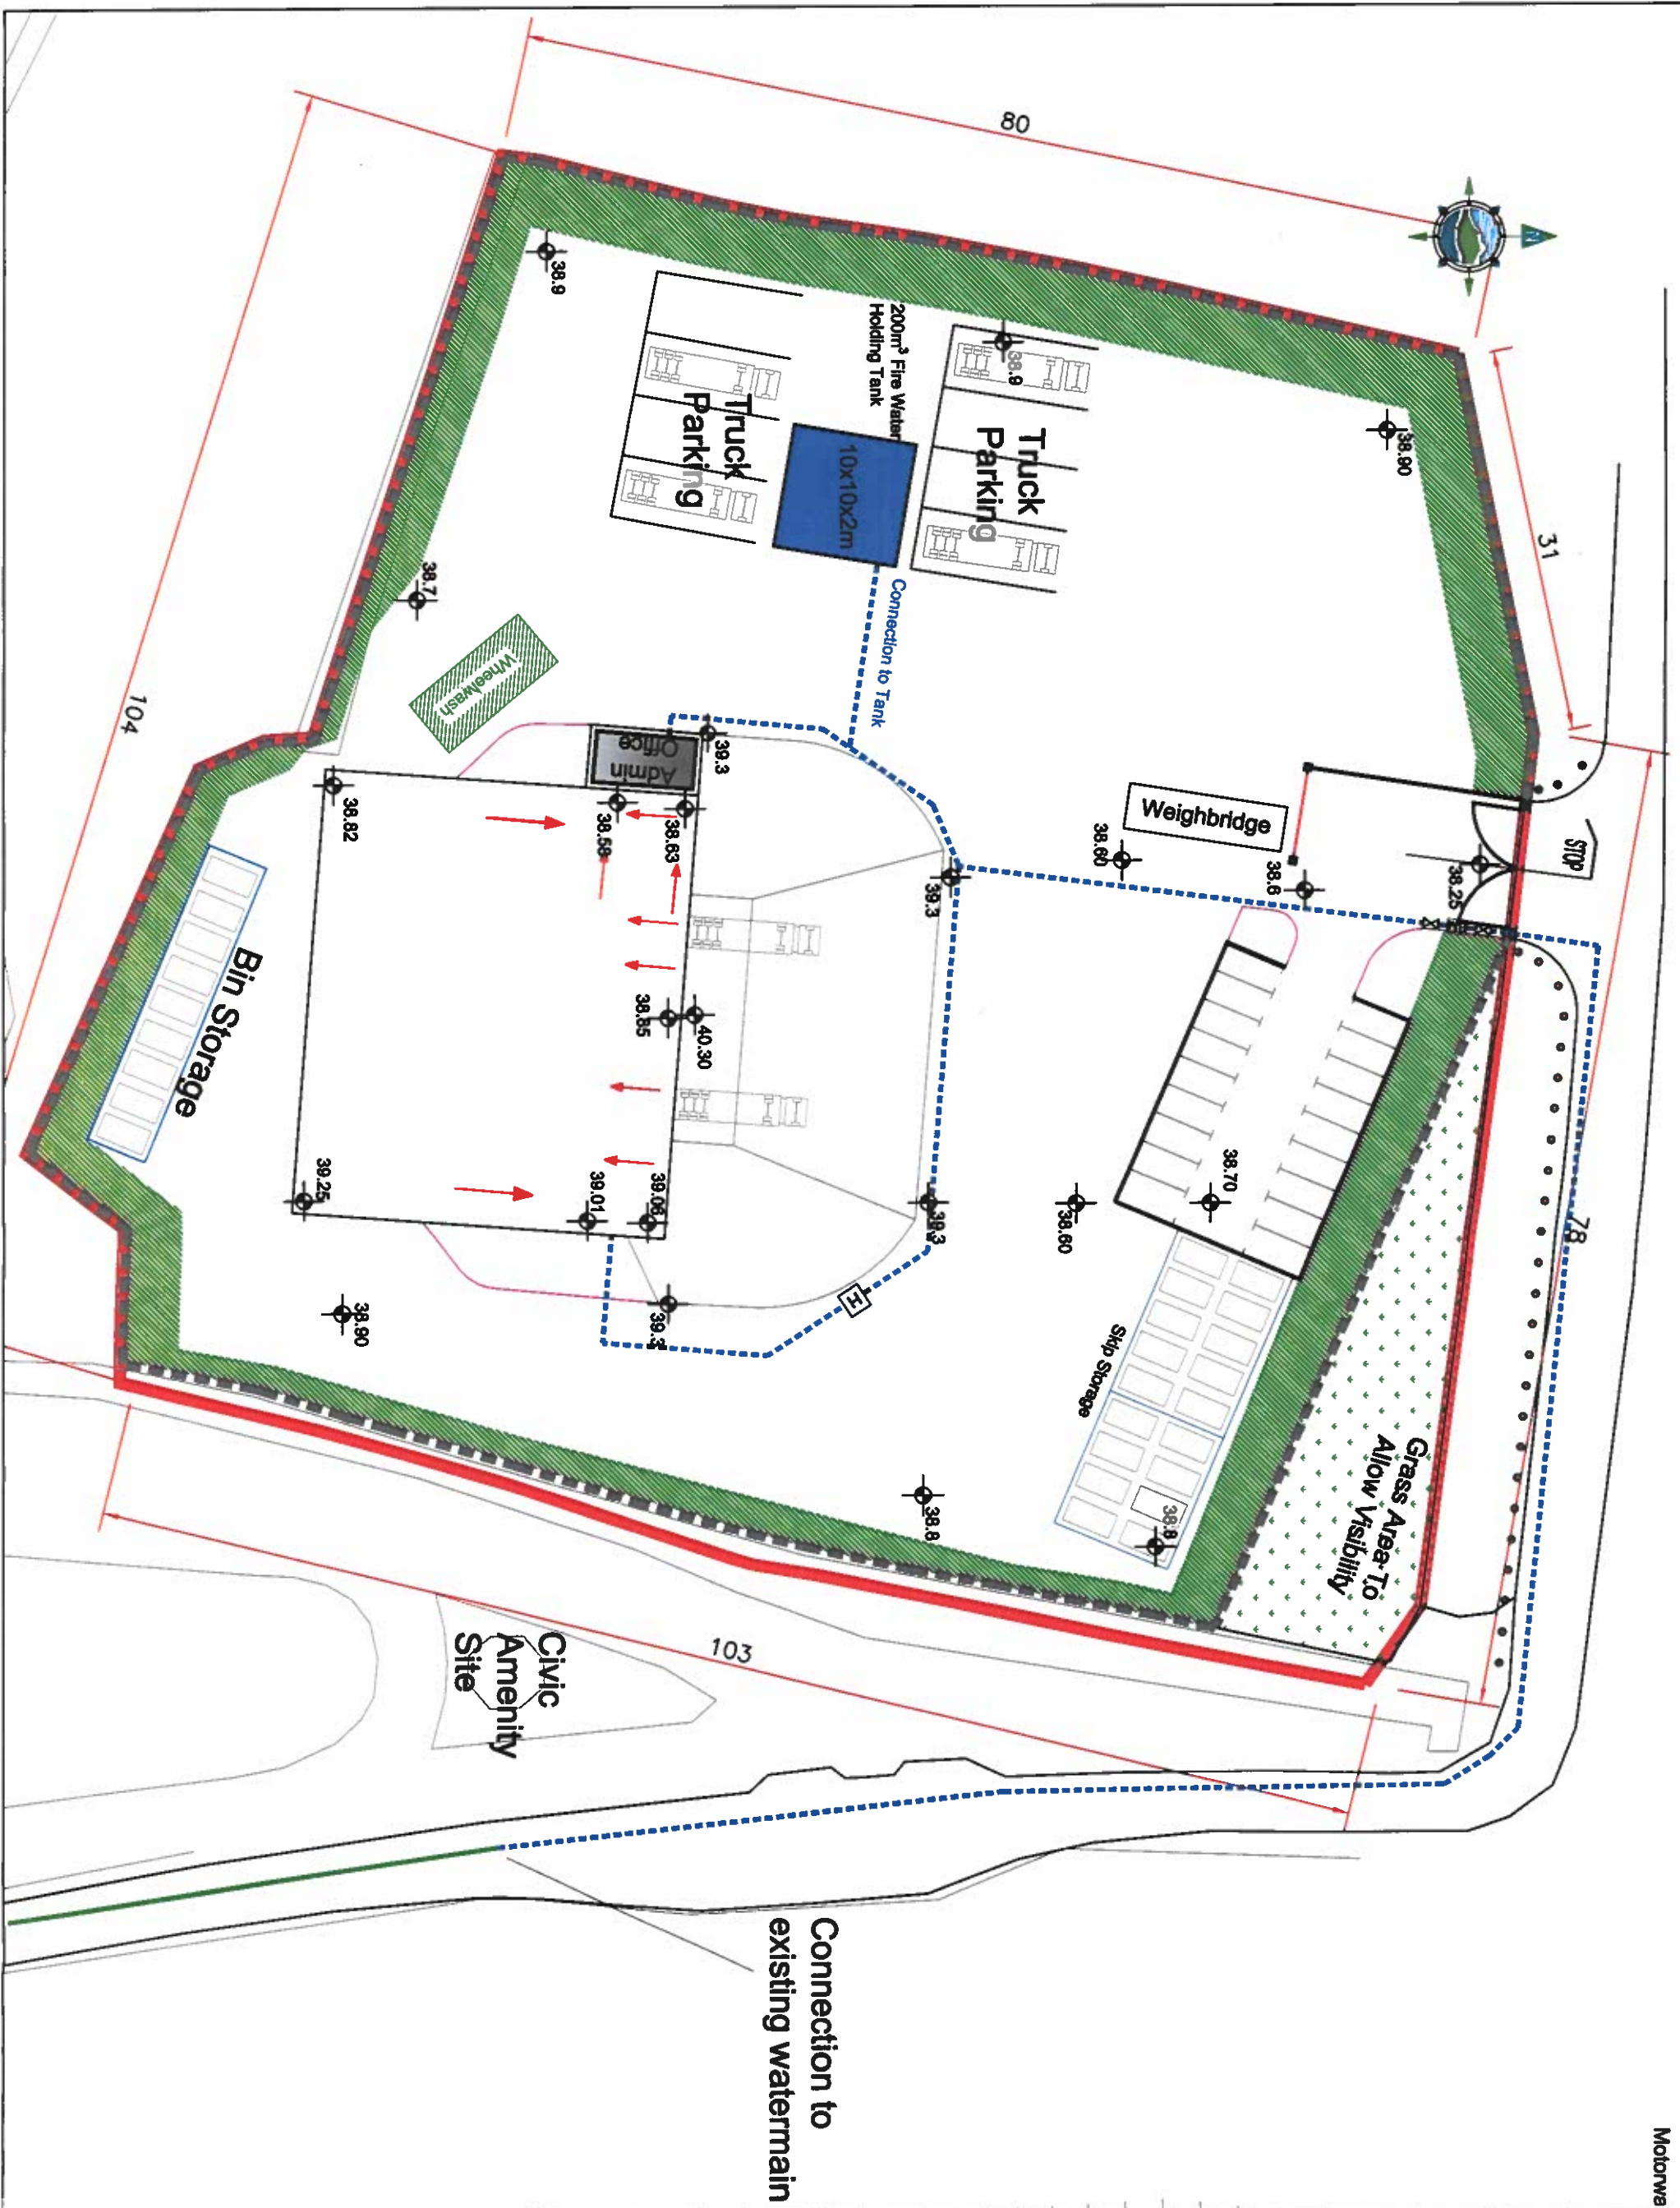

Connection to existing watermain

Motorwa

- PROPOSED KERB LINE
- 2m HIGH BOUNDARY WALL
- EXISTING WATERMAIN
- PROPOSED 25mmØ WATERMAIN
- PROPOSED SLUICE VALVE
- PROPOSED FIRE HYDRANT
- PROPOSED BULK WATER METER
- WHEELWASH

Legend

- NOTES:**
1. DIMENSIONS ONLY TO BE TAKEN FROM THIS DRAWING
 2. ALL DRAWINGS TO BE CHECKED BY THE CONTRACTOR ON SITE
 3. ENGINEER/EMPLOYERS REPRESENTATIVE AS APPROPRIATE TO BE INFORMED BY THE CONTRACTOR OF ANY DISCREPANCIES BEFORE ANY WORK COMMENCES
 4. THE CONTRACTOR SHALL UNDERTAKE A THOROUGH CHECK FOR THE ACTUAL LOCATION OF ALL SERVICES/UTILITIES ABOVE AND BELOW GROUND BEFORE ANY WORK COMMENCES
 5. ALL LEVELS SHOWN RELATE TO ORDNANCE SURVEY DATUM AT MALIN HEAD

No.	Date	Description	By	Check
1	07/06/2019	ISSUED TO PLANNING	BH	SM

Client: MR. SEAN CURRAN

Project: POLLBOY WASTE TRANSFER STATION

Title: WATERMAIN LAYOUT


Scale @ A3: 1:500 @ A1: 1:250

Prepared by: MK
Checked: BH
Date: June 2019

Project Director: J.P. Kelly
Drawing Status: Waste Licence Application

TOBIN
 TOBIN Consulting Engineers,
 Fairgreen House, Fairgreen Road,
 Galway, Ireland.
 Tel: +353-091-566211
 Fax: +353-091-565368
 e-mail: galway@tobin.ie
 www.tobin.ie

Drawing No: 7526-2444
 Revision: A

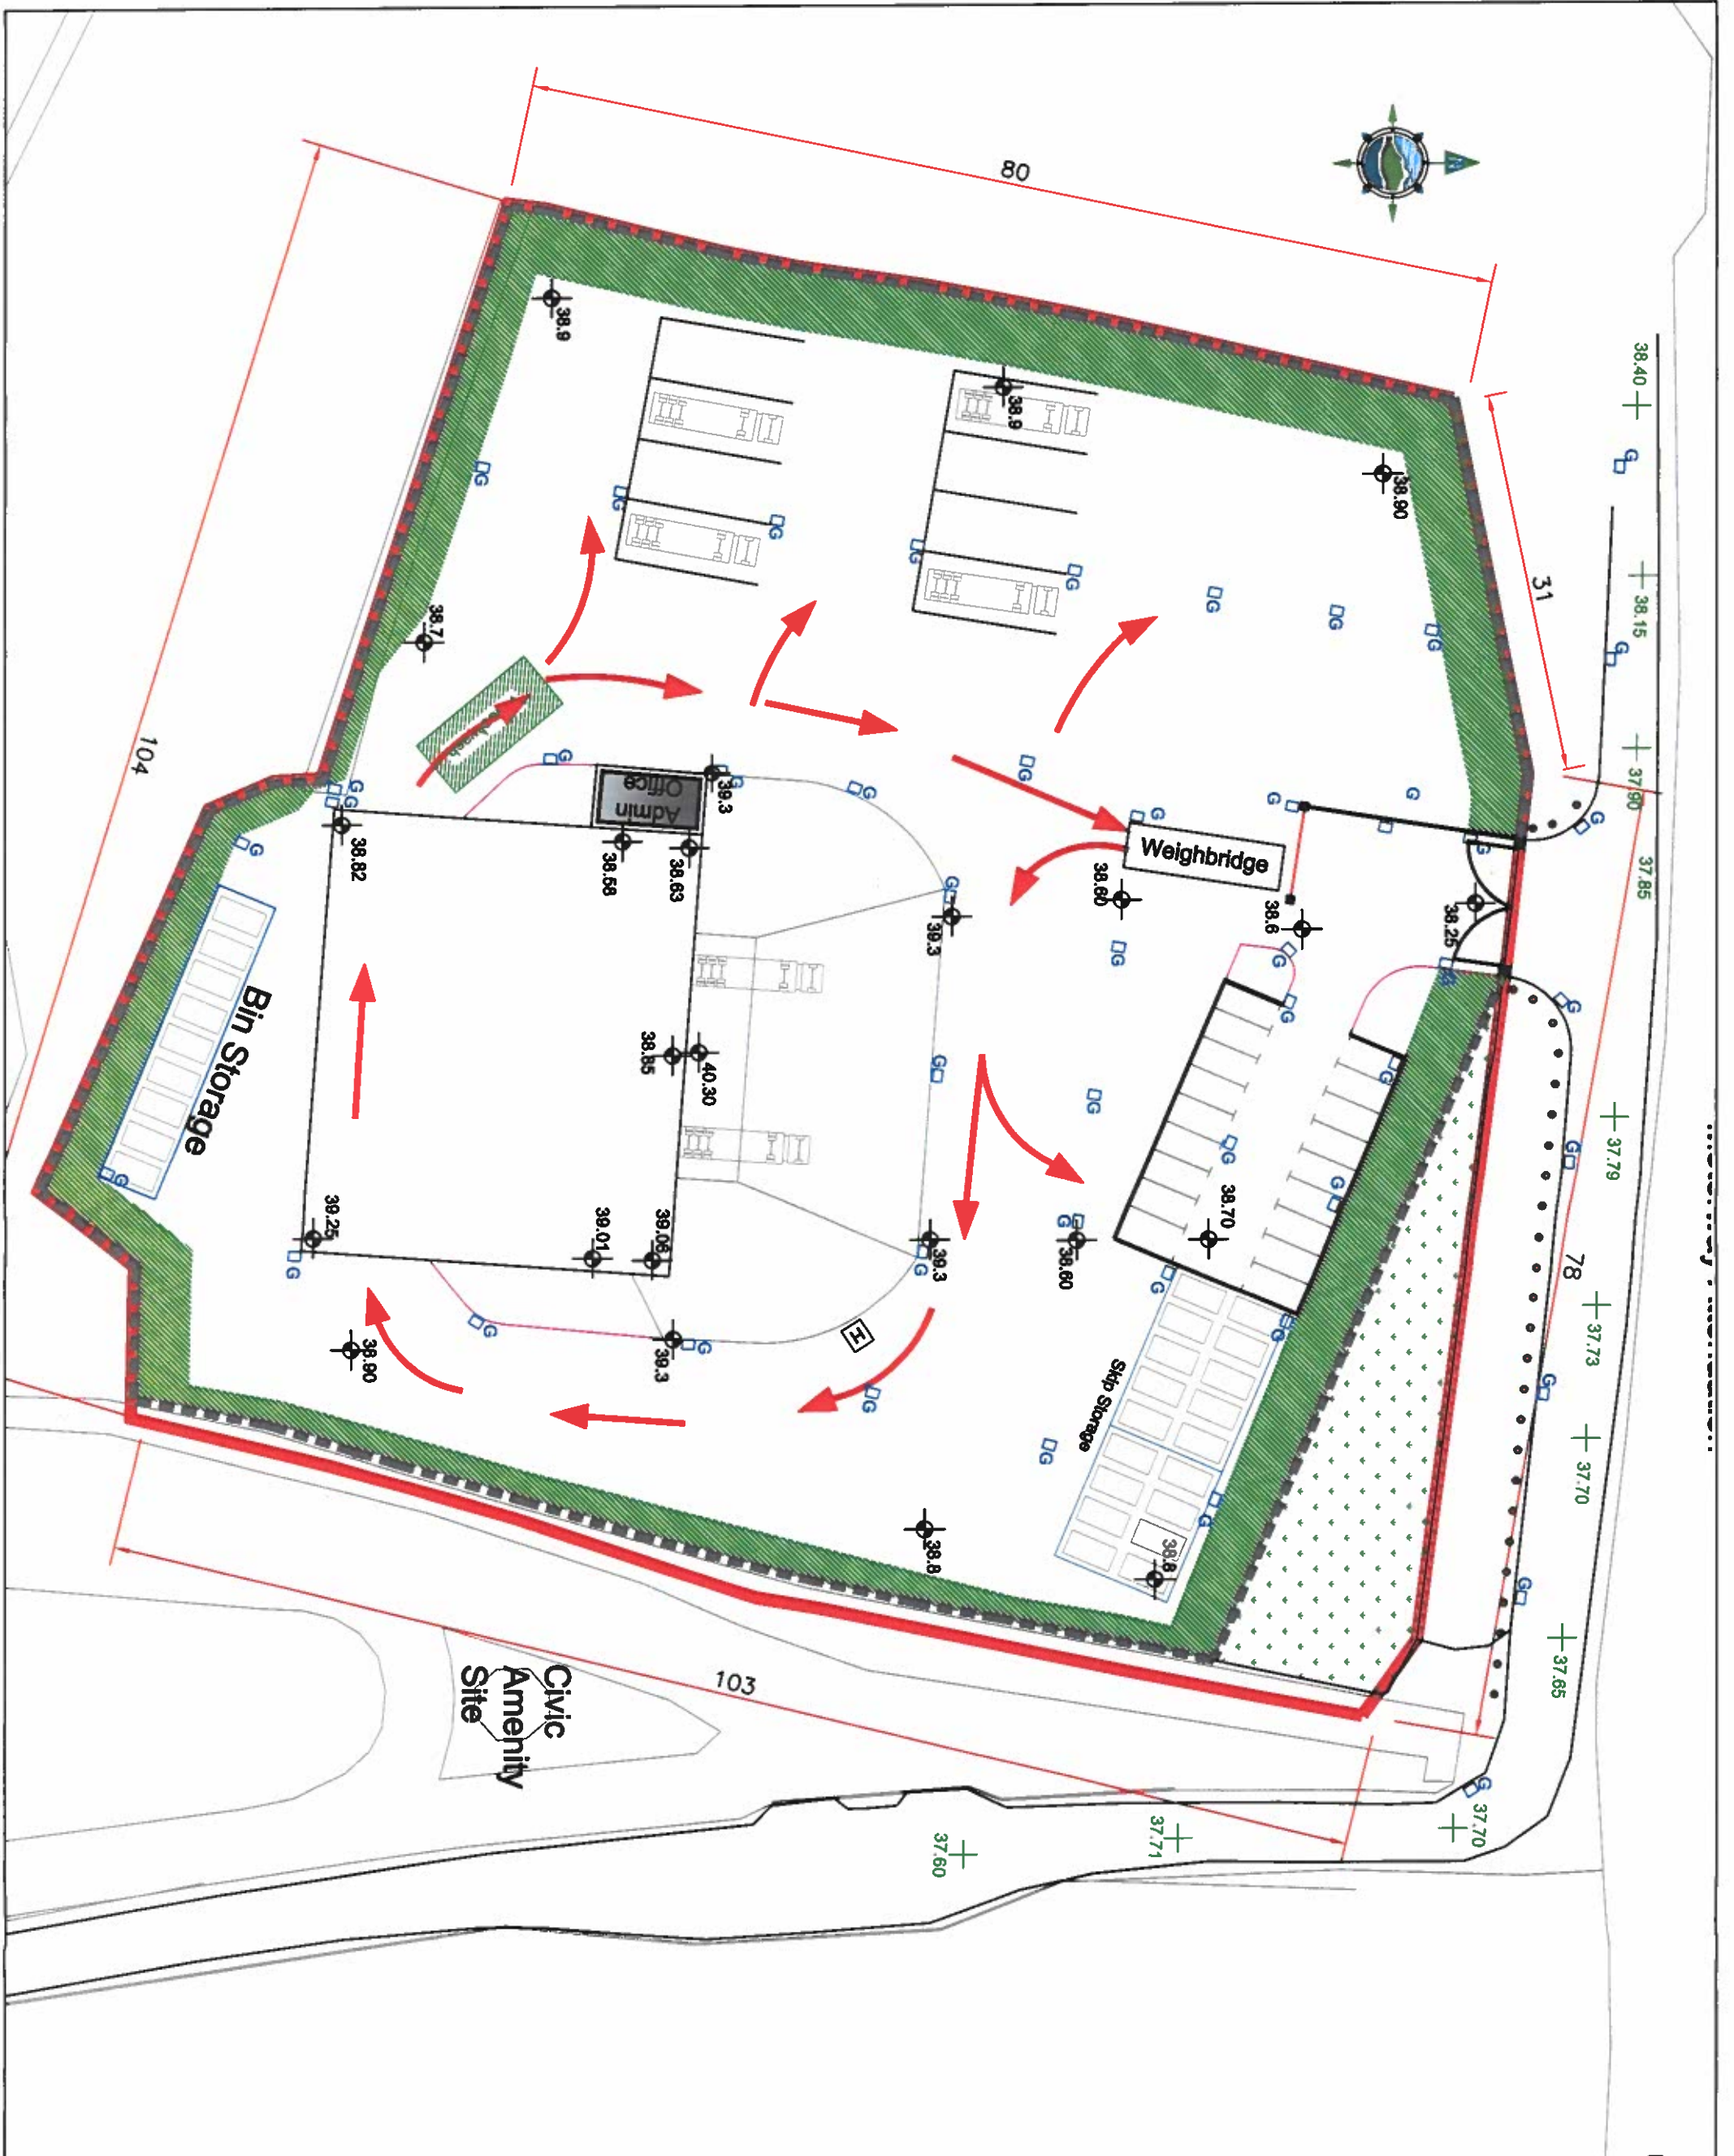

Legend

- Proposed Kerb Line
- Existing Road Level
- Proposed Level
- Road Gully
- 2m High Boundary Wall
- Direction of Travel for Trucks
- Wheel Wash Area

- NOTES:**
1. FIGURED DIMENSIONS ONLY TO BE TAKEN FROM THIS DRAWING.
 2. ALL DRAWINGS TO BE CHECKED BY THE CONTRACTOR ON SITE.
 3. ENGINEER/EMPLOYERS REPRESENTATIVE AS APPROPRIATE TO BE INFORMED BY THE CONTRACTOR OF ANY DISCREPANCIES BEFORE ANY WORK COMMENCES.
 4. THE CONTRACTOR SHALL UNDERTAKE A THOROUGH CHECK FOR THE ACTUAL LOCATION OF ALL SERVICES/UTILITIES ABOVE AND BELOW GROUND, BEFORE ANY WORK COMMENCES.
 5. ALL LEVELS SHOWN RELATE TO ORDNANCE SURVEY DATUM AT MAIN HEAD.


Rev	Date	Description	By	CHKD
1	07/05/2019	ISSUED FOR TENDER	LM	SH

Client: MR. SEAN CURRAN
 Project: POLLBOY WASTE TRANSFER STATION
 Title: Roads Layout (Showing Traffic Routes)

Scale @ A1: 1:500 @ A1: 1:250
 Prepared By: MK
 Checked: BH
 Date: June 2019
 Project Director: J.P. Kelly
 Drawing Status: Waste Licence Application

TOBIN
 ENGINEERS & ARCHITECTS
 TOBIN Consulting Engineers,
 Fatigueen House, Fatigueen Road,
 Galway, Ireland.
 Tel: +353-91-866211
 Fax: +353-91-866211
 Email: galway@tobin.ie
 www.tobin.ie

Drawing No: 7526-2445
 Revision: A

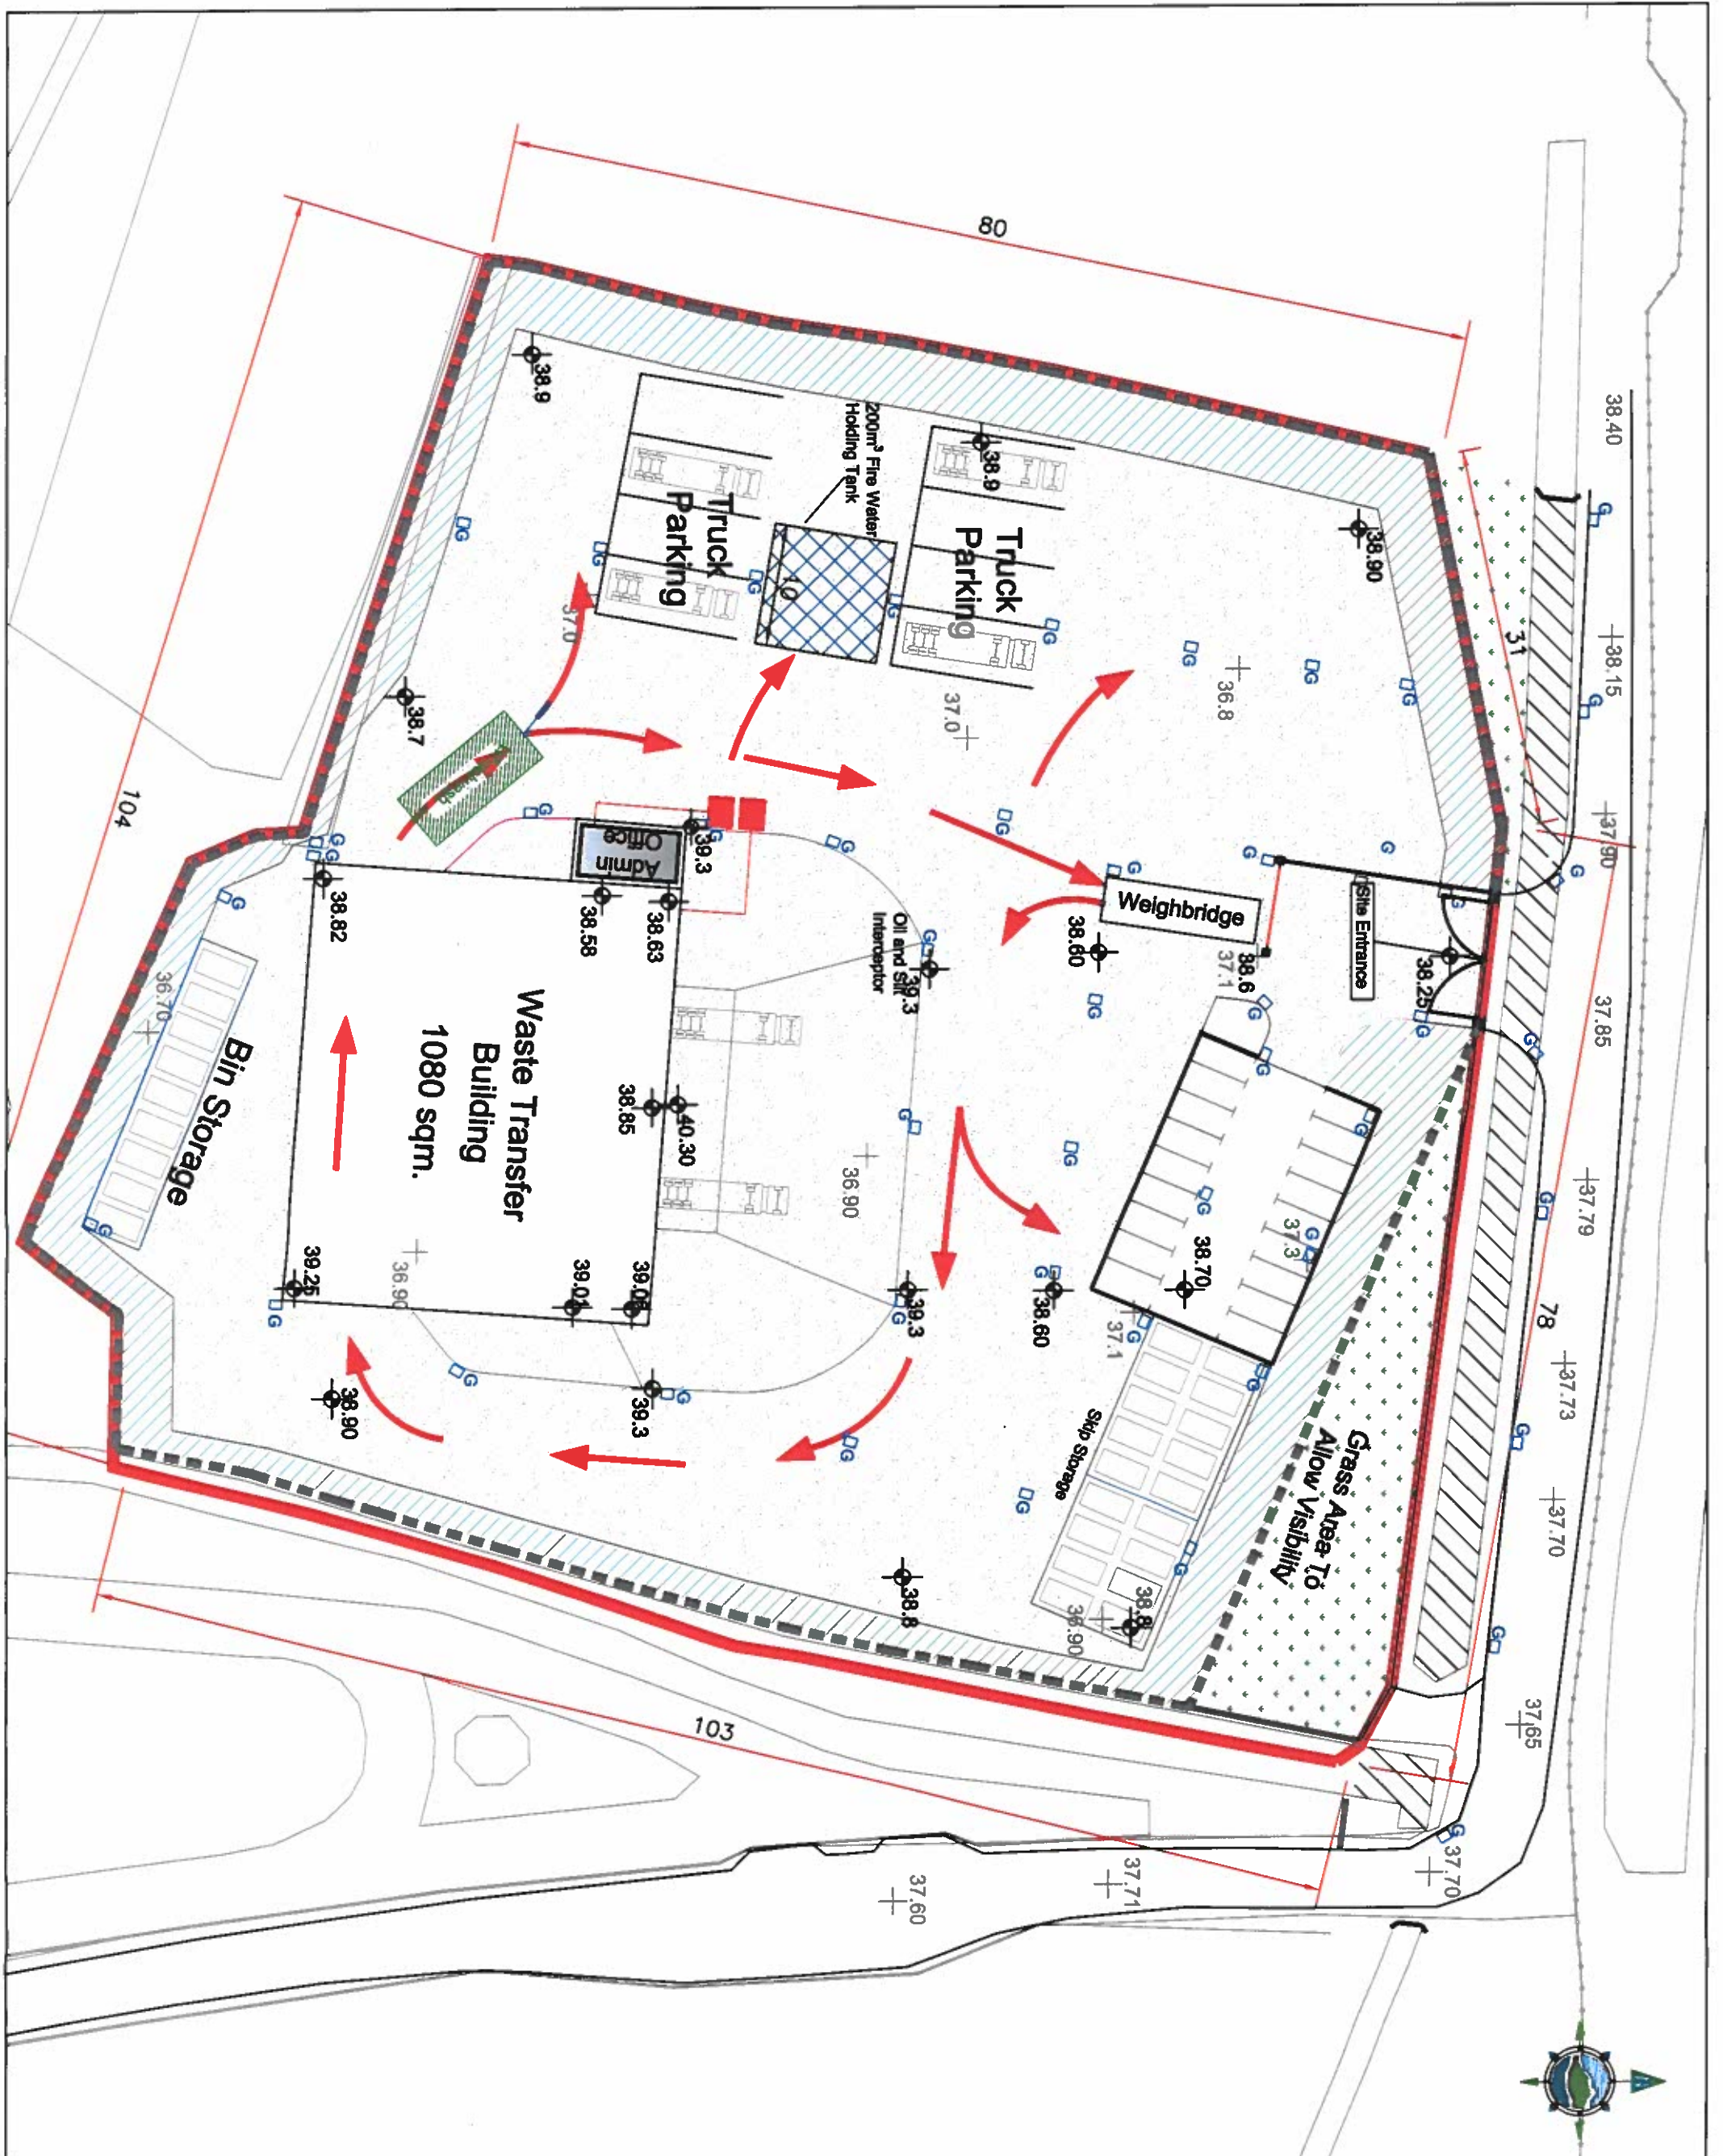

- Legend**
- Site Boundary
 - Site Entrance
 - Road Gully
 - Proposed Sewage Holding Tank and Floor Wash Tank
 - Vehicle Direction of Travel
 - Planted Screening - Grassed Area
 - Planted Screening
 - Hardstand
 - Proposed Filled Existing Drain Grassed to Road Edge
 - Existing Level
 - Proposed Level
 - 2m HIGH BOUNDARY WALL
 - Fire Tank
 - Wheel Wash Area

- NOTES:**
1. FIGURED DIMENSIONS ONLY TO BE TAKEN FROM THIS DRAWING.
 2. ALL DRAWINGS TO BE CHECKED BY THE CONTRACTOR ON SITE.
 3. ENGINEERS/EMPLOYERS REPRESENTATIVE AS APPROPRIATE, TO BE INFORMED BY THE CONTRACTOR OF ANY DISCREPANCIES.
 4. THE CONTRACTOR SHALL UNDERTAKE A THOROUGH CHECK FOR THE ACTUAL LOCATION OF ALL SERVICES/UTILITIES ABOVE AND BELOW GROUND, BEFORE ANY WORK COMMENCES.
 5. ALL LEVELS SHOWN RELATE TO ORDNANCE SURVEY DATUM AT MALIN HEAD.

Rev	Date	Description	By	Chk
1	31/08/19	Final Issue	JK	BR

Client: **Mr. Sean Curran**

Project: **Pollboy Waste Transfer station**

Title: **Plan Showing Hardstand Area**

Scale @ A3: 1:500 @ A1: 1:250

Prepared by: **JK** Date: **June 2019**

Checked by: **BR**


Project Director: **Michael McDonnell**

Drawing Status: **Waste Licence Permit**


TOBIN
 Tobin Consulting Engineers,
 Falgreen House, Falgreen Road,
 Galway, Ireland.
 Tel: +353 (0)91-585211
 Fax: +353 (0)91-585338
 Email: gavin@tobin.ie
 www.tobin.ie

Drawing No.: **7526-2446**

Revision: **A**

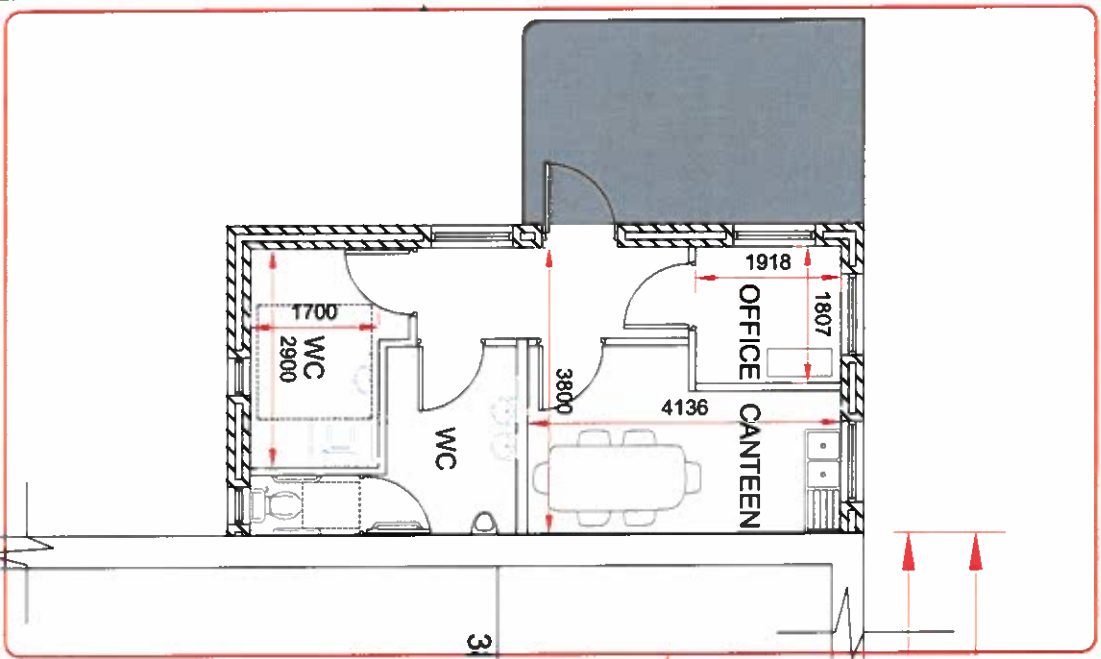

Plan of Admin Building
Scale @A1/A3 1:50 / 1:100

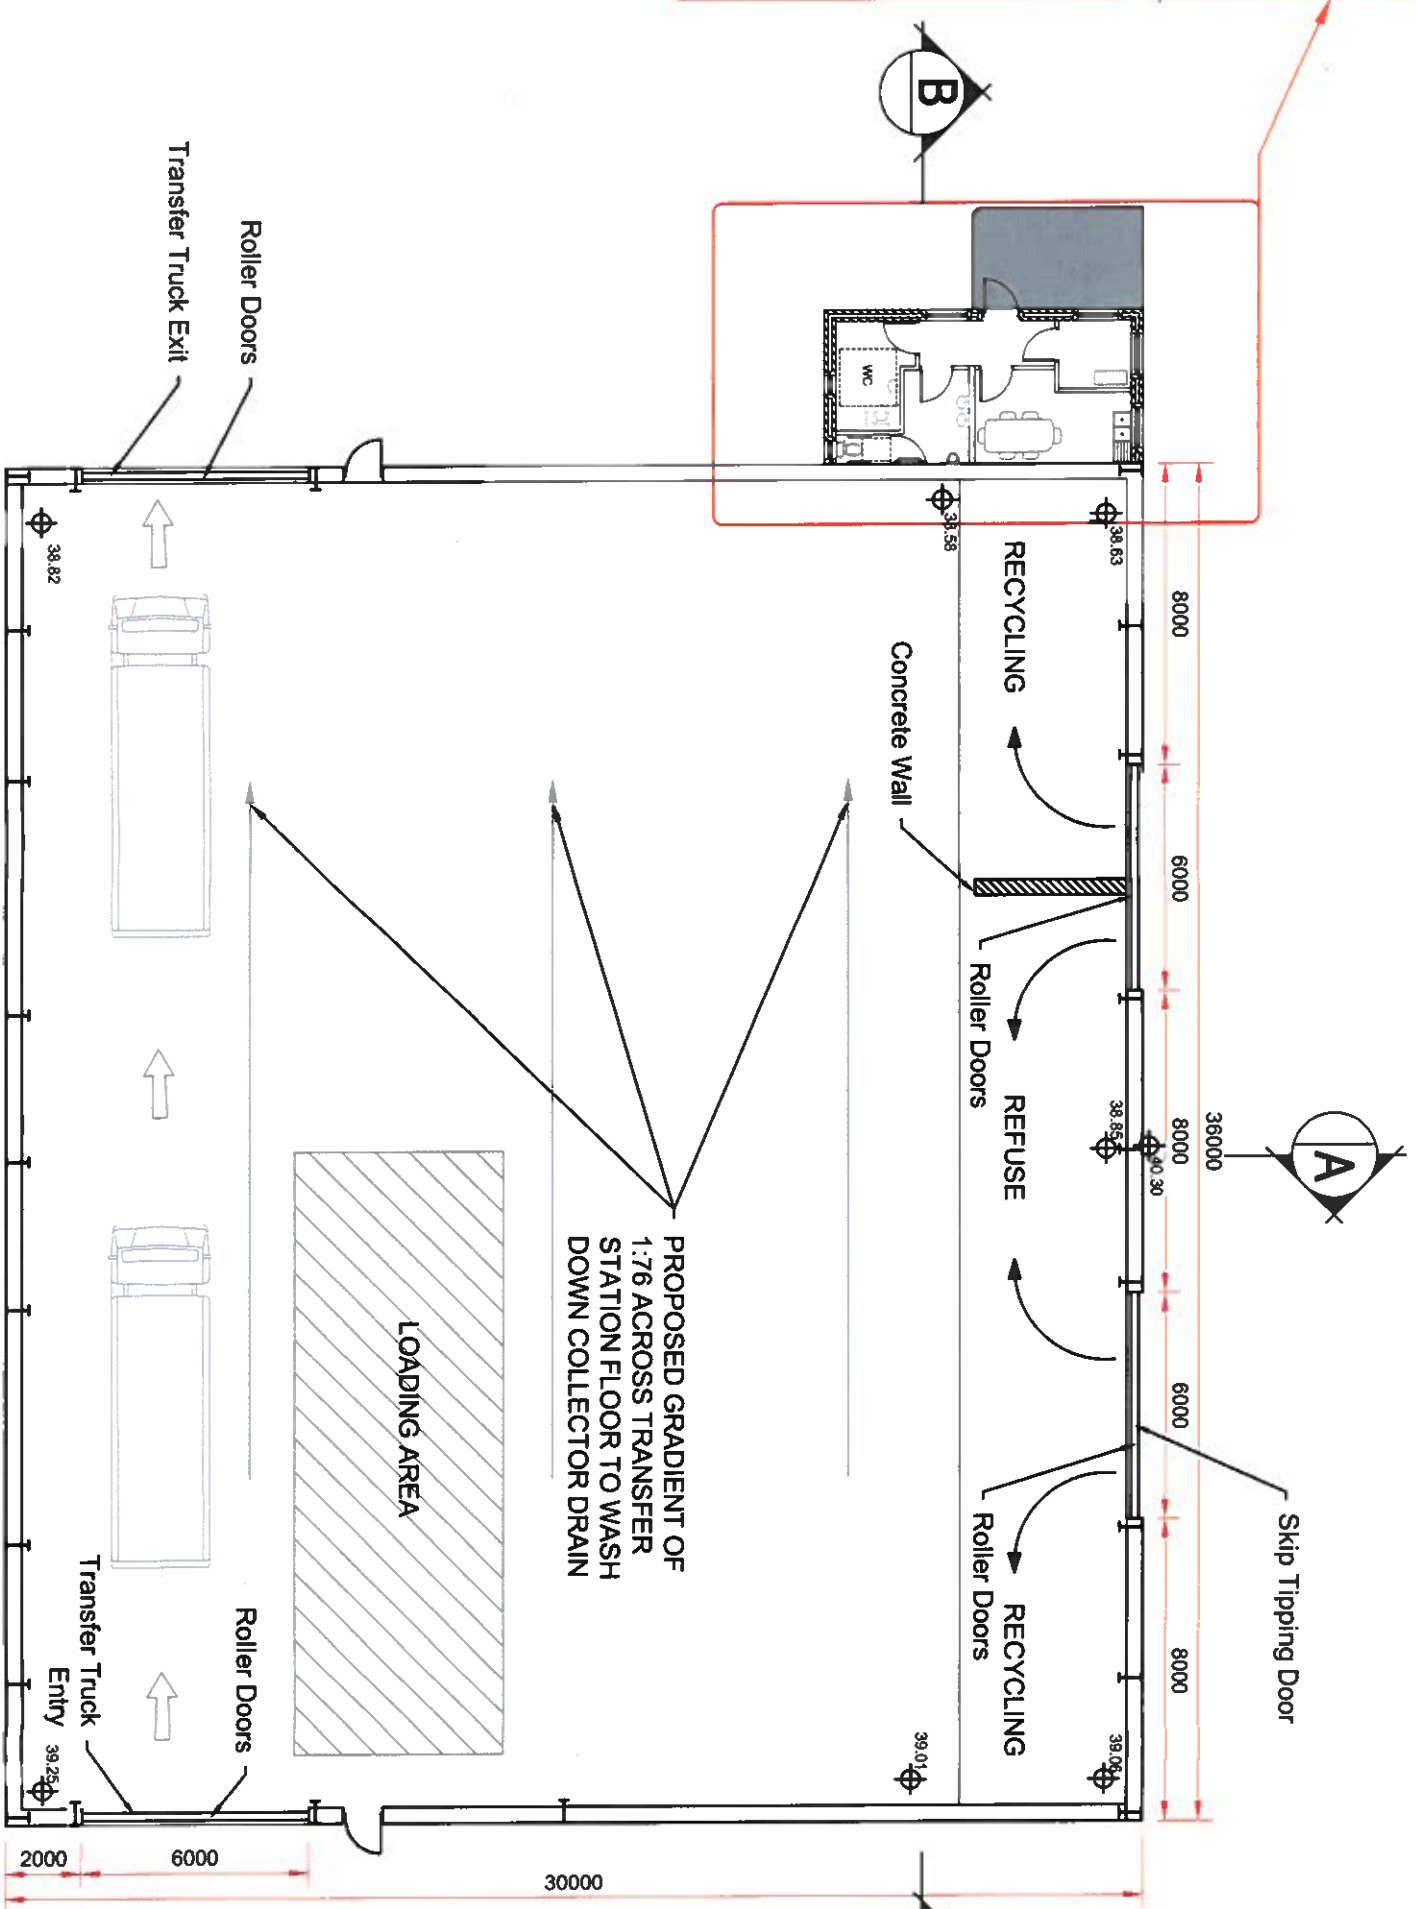

Plan of Waste Transfer Station
Scale @A1/A3 1:100 / 1:200

- NOTES:**
1. FIGURED DIMENSIONS ONLY TO BE TAKEN FROM THIS DRAWING.
 2. ALL DRAWINGS TO BE CHECKED BY THE CONTRACTOR ON SITE.
 3. ENGINEER/PLANNERS REPRESENTATIVE AS APPROPRIATE TO BE INFORMED BY THE CONTRACTOR OF ANY WORK COMMENCES BEFORE ANY WORK COMMENCES.
 4. THE CONTRACTOR SHALL UNDERTAKE A THOROUGH CHECK FOR THE ACTUAL LOCATION OF ALL SERVICES/UTILITIES ABOVE AND BELOW GROUND, BEFORE ANY WORK COMMENCES.
 5. ALL LEVELS SHOWN RELATE TO ORDNANCE SURVEY DATUM AT MALIN HEAD.

Rev	Date	Description	By	CHKD
A	21/06/18	Final Issue	JK	BR

Client: **Mr. Sean Curran**

Project: **Pollboy Waste Transfer Station**

Title: **Proposed Transfer Station and Ancillary Staff Facilities Plan**

Scale @ A3: **As Shown**

Prepared by: **JK** Date: **June 2019**

Checked by: **BR**





Project Director: **Michael McDonnell**

Drawing Status: **Waste Licence Application**

TOBIN
Consulting Engineers,
Falgout House, Falgout Road,
Galway, Ireland.
Tel: +353-91-866211
Fax: +353-91-866388
email: galway@tobin.ie
www.tobin.ie

Drawing No.: **7526-2447**

Revision: **A**

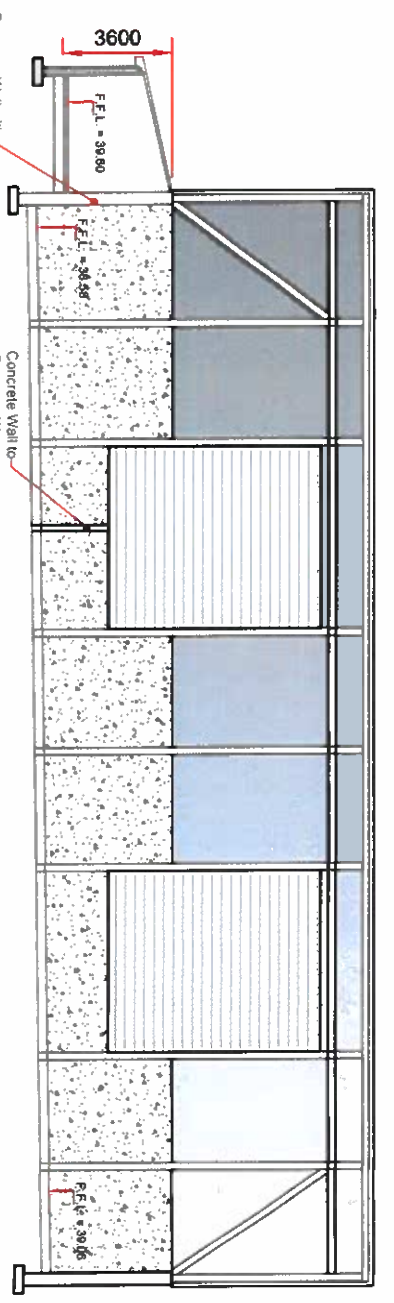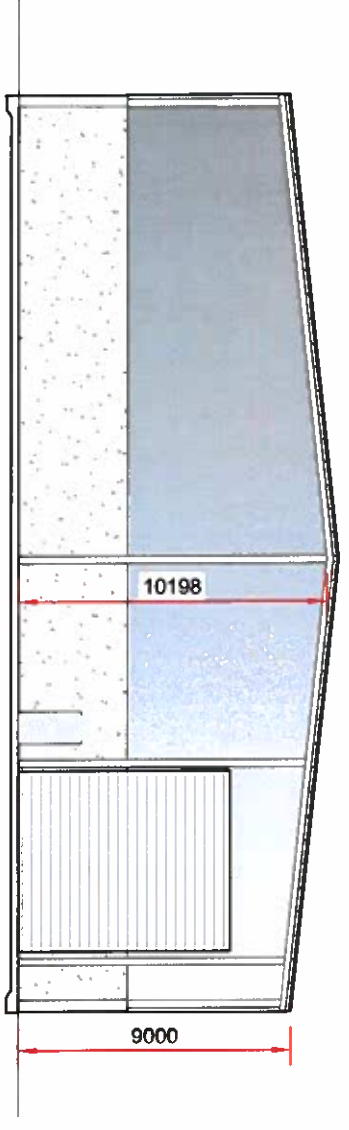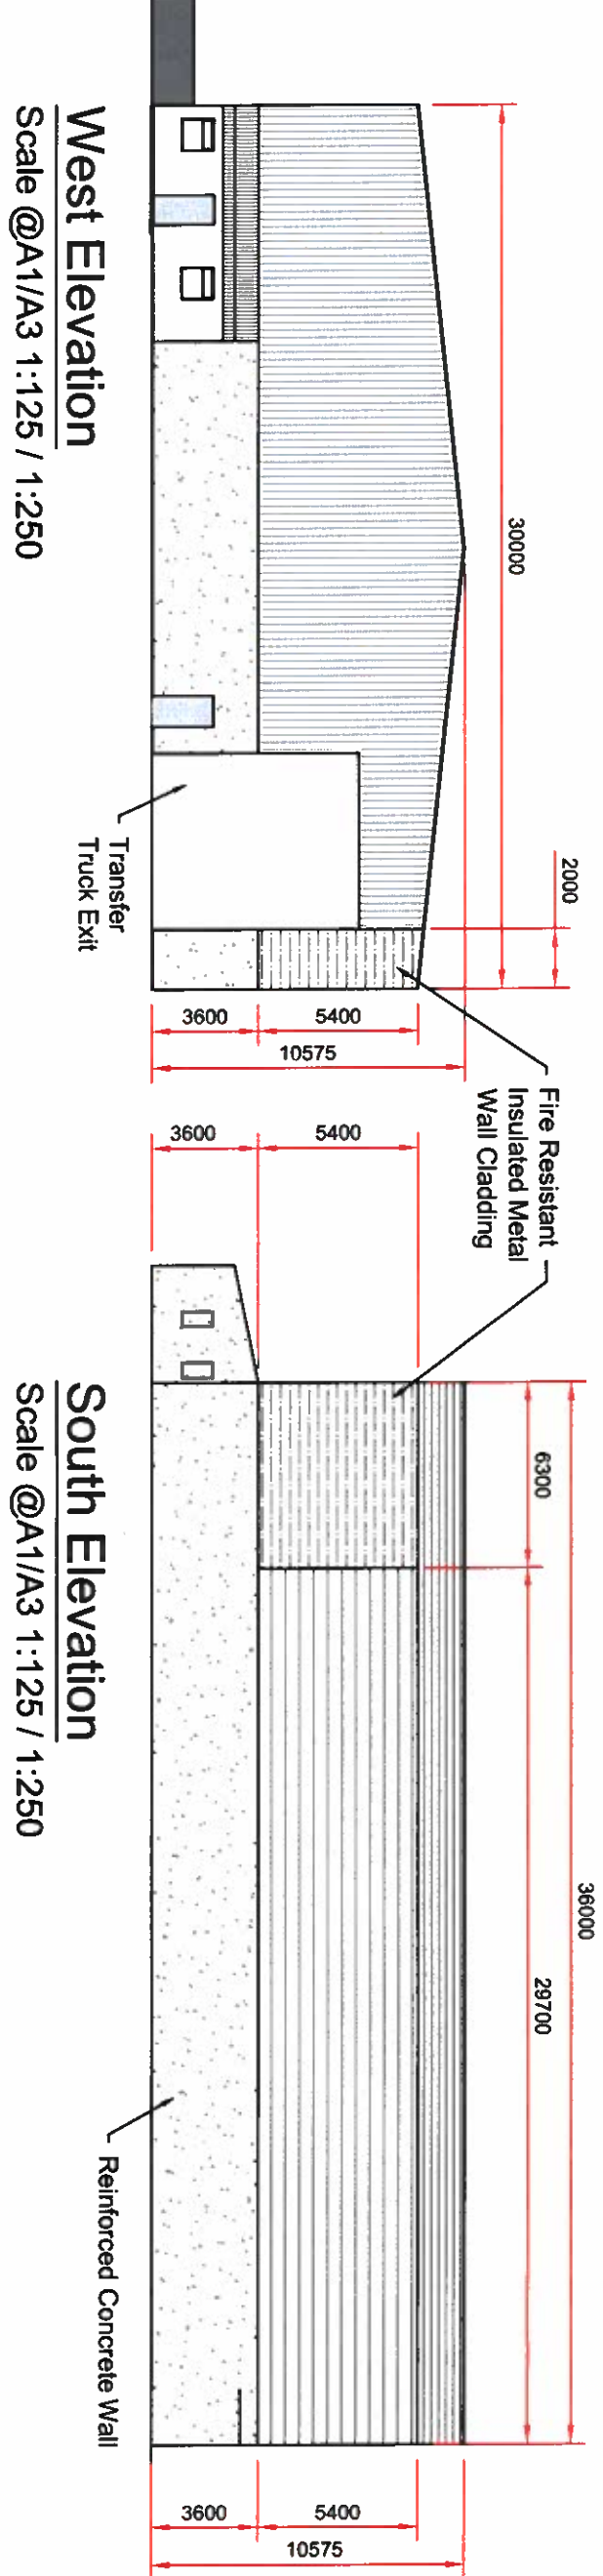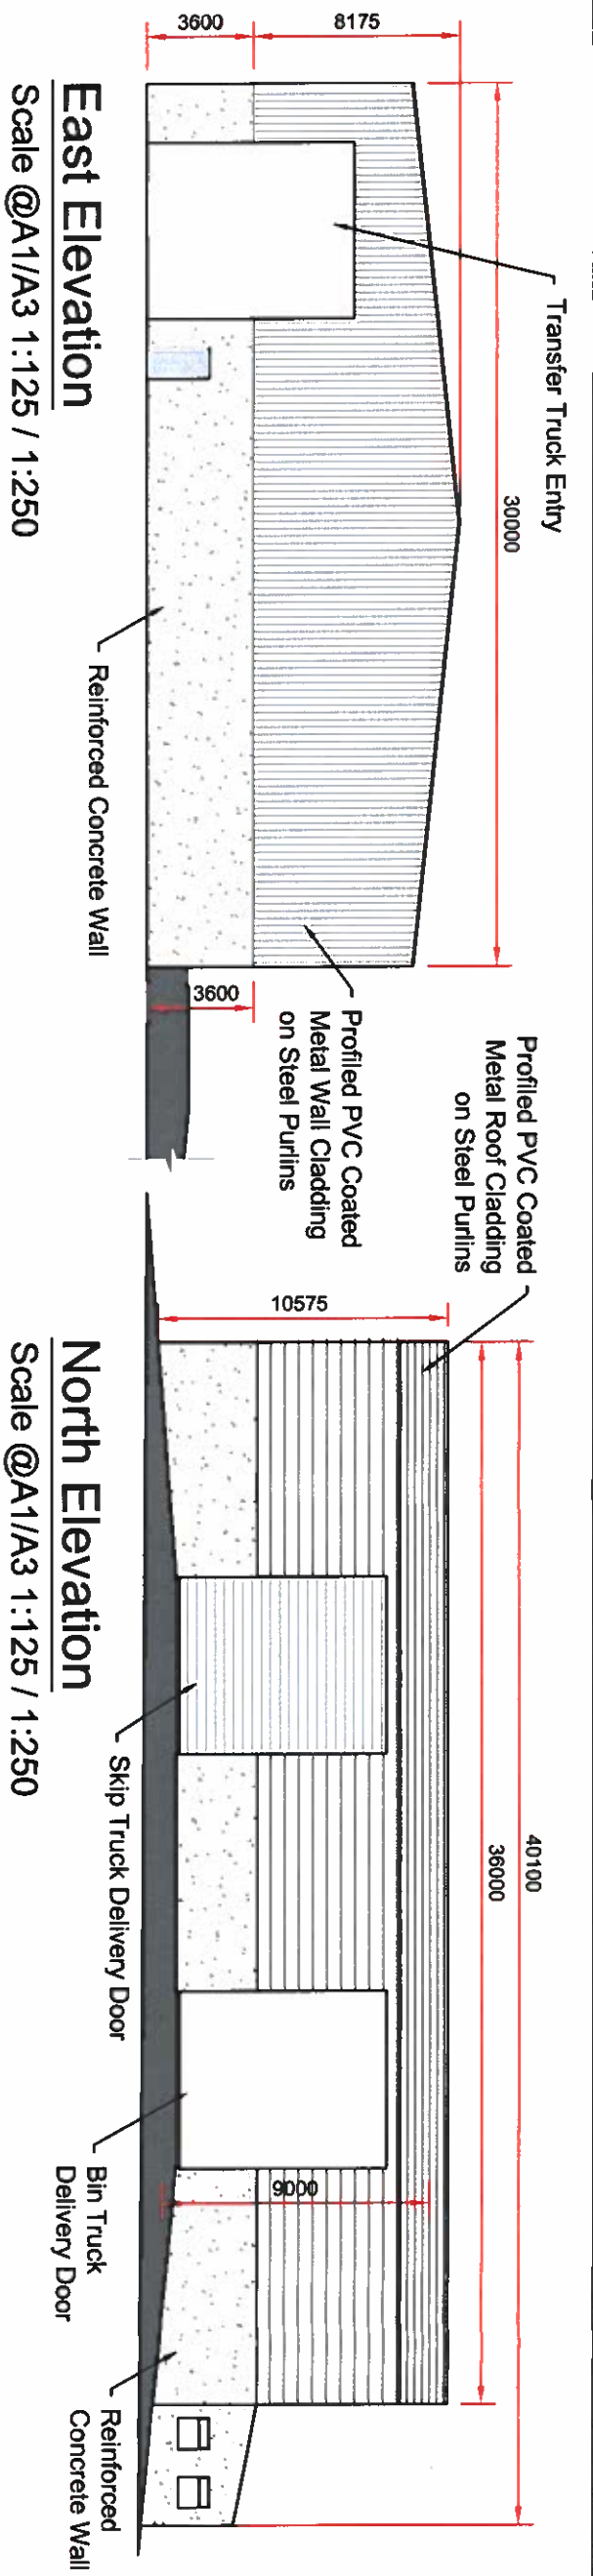

- NOTES:**
1. FIGURED DIMENSIONS ONLY TO BE TAKEN FROM THIS DRAWING.
 2. ALL DRAWINGS TO BE CHECKED BY THE CONTRACTOR ON SITE.
 3. ENGINEER/EMPLOYERS REPRESENTATIVE AS APPROPRIATE TO BE INFORMED BY THE CONTRACTOR OF ANY DISCREPANCIES BEFORE ANY WORK COMMENCES.
 4. THE CONTRACTOR SHALL UNDERTAKE A THOROUGH CHECK FOR THE ACTUAL LOCATION OF ALL SERVICES/UTILITIES ABOVE AND BELOW GROUND, BEFORE ANY WORK COMMENCES.
 5. ALL LEVELS SHOWN RELATE TO ORDNANCE SURVEY DATUM AT MALLENHEAD.

Rev	Date	Description	By	Check
A	24/06/19	Final Issue	FG	BR

Client: **Mr. Sean Curran**

Project: **Pollboy Waste Transfer Station**

Title: **Proposed Transfer Station and Ancillary Staff Facilities Elevations And Sections**

Scale @A3: **1:250 Scale @A1 1:125**


Prepared by: **JK** Checked: **BR** Date: **June 2019**

Project Director: **Michael McDonnell**

Drawing Status: **Waste Licence Application**

Tobin Consulting Engineers
Fairgreen House, Fairgreen Road,
Galwey, Ireland
Tel: +353-(0)91-5662711
Fax: +353-(0)91-5663398
e-mail: galwey@tobin.ie
www.tobin.ie

Drawing No: **7526-2448** Revision: **A**

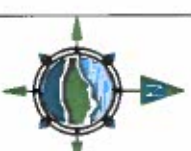

SITE ENTRANCE

SITE NOTICE LOCATIONS


SITE BOUNDARY
OUTLINED RED

Proposed Transfer
Station FFL 39.25

Pollboy Civic Amenity Facility

OWNERSHIP LINE

Existing Pollboy Landfill Facility

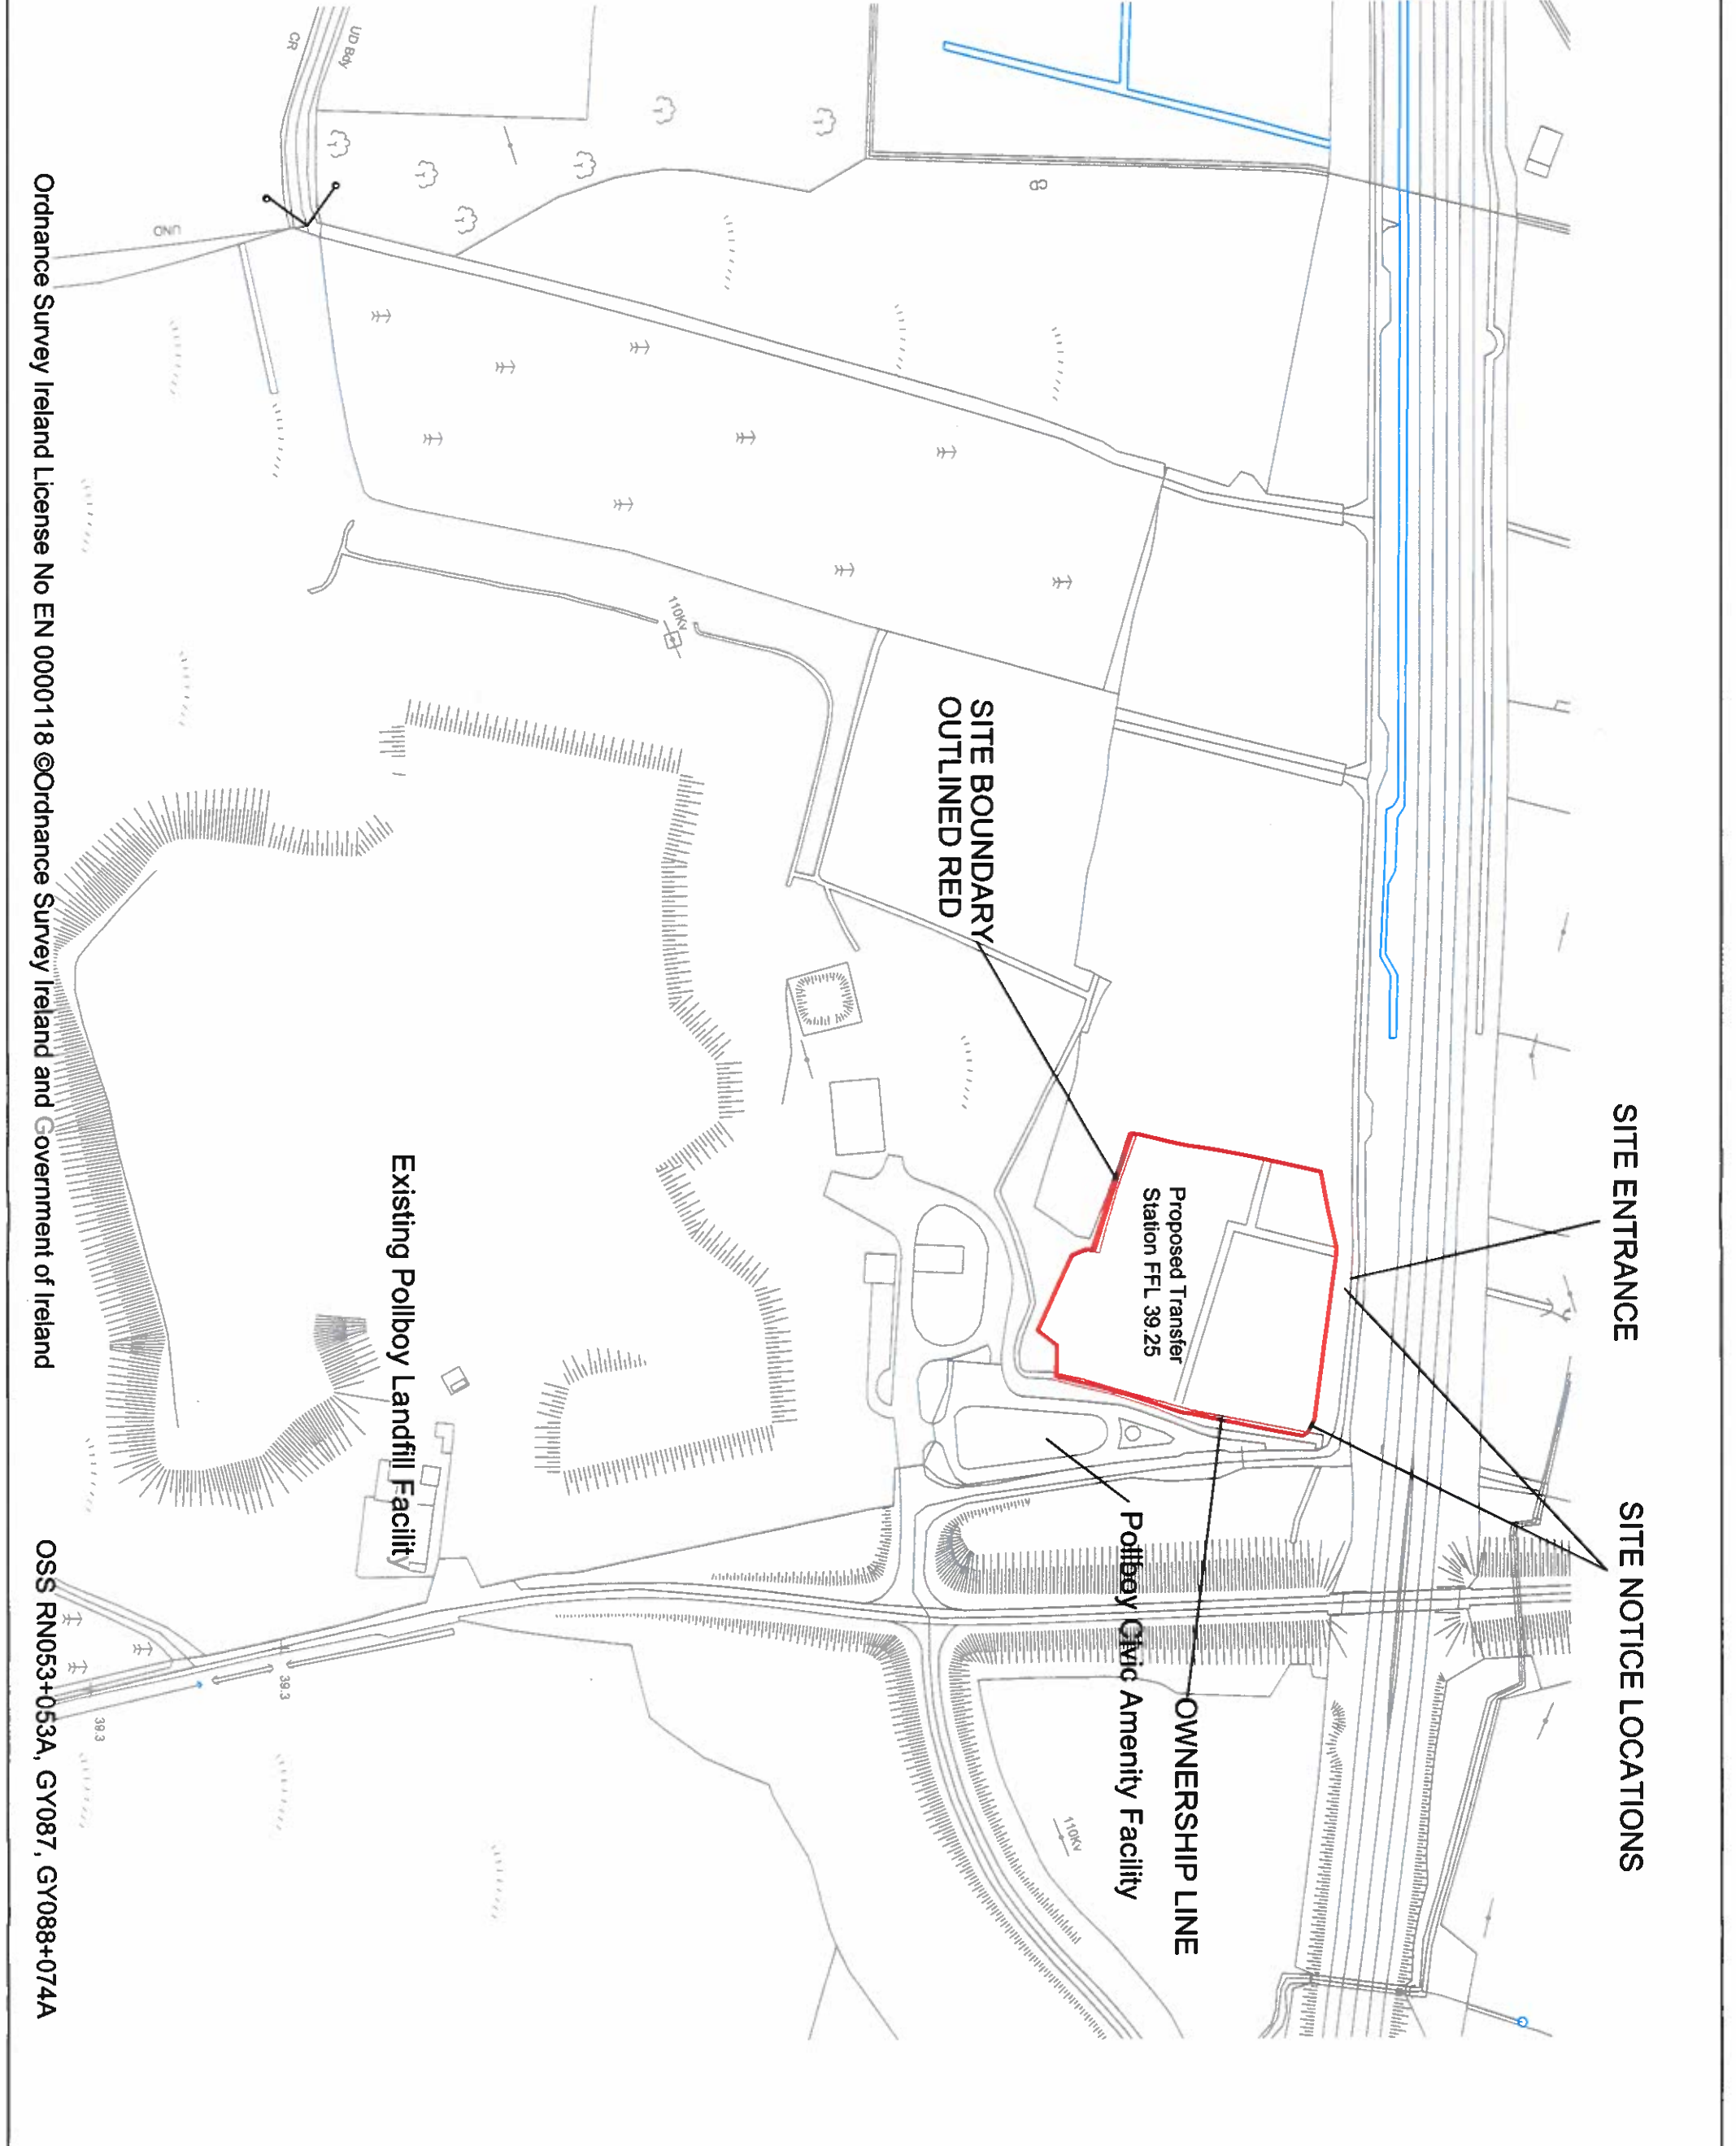

- NOTES:**
1. FIGURED DIMENSIONS ONLY TO BE TAKEN FROM THIS DRAWING.
 2. ALL DRAWINGS TO BE CHECKED BY THE CONTRACTOR ON SITE.
 3. ENGINEER/EMPLOYERS REPRESENTATIVE AS APPROPRIATE TO BE INFORMED BY THE CONTRACTOR OF ANY DISCREPANCIES BEFORE ANY WORK COMMENCES.
 4. THE CONTRACTOR SHALL UNDERTAKE A THOROUGH CHECK FOR THE ACTUAL LOCATION OF SERVICES PRIOR TO ANY WORK COMMENCES ABOVE AND BELOW GROUND. BEFORE ANY ALL LEVELS SHOWN RELATE TO ORDNANCE SURVEY DATUM AT MALIN HEAD.

Rev	Date	Description	By	Check
1	18/06/19	Final Issue	JG	MR

Client: Mr. Sean Curran

Project: Pollboy Waste Transfer Station

Title: Site Location and Site Boundary [Site Notice Location Map]

Scale: @ A3: 1:2500 @ A1: 1:1250
Prepared by: JK
Checked by: BR
Date: June 2019
Project Director: Michael McDonnell
Drawing Status: Waste Licence Application

TOBIN
 Consulting Engineers,
 Fairgreen House, Fairgreen Road,
 Ballinacorney, Carrigrohane,
 Co. Cork.
 Tel: +353-1-9091-696711
 Fax: +353-1-9091-696388
 e-mail: gahery@tobin.ie
 www.tobin.ie

Drawing No.: 7526-2450
Revision: A