



PARTS LIST


ITEM NO	COMPONENT	PART NO.	DESCRIPTION	MANUFACTURER	QTY	REMARKS
1	TOP PIECE	-	28 35/32"W x 24 1/2"H x TWELVE SIDE TOP PIECE - GFRC	GIST	1	COLOR OPTIONAL
2	BASIN	-	9 1/2"H x 44"W x 44"L BASIN - GFRC	GIST	1	COLOR OPTIONAL
3	Round Riser	-	8 1/4"H ROUND RISER - GFRC	GIST	1	COLOR OPTIONAL
4	TUBING	-	3/4" DIA PVC COUPLER SOCKET END	-	1	PRE-INSTALLED
5		-	3/4"x1/2" DIA PVC CONCENTRIC REDUCER SOCKET END	-	1	PRE-INSTALLED
6		-	1/2" DIA x 12"LG PVC PIPE PLAIN END	-	1	PRE-INSTALLED
7		-	1-1/4" DIA x 1-1/8"LG PVC PIPE SLEEVE PLAIN END	-	1	PRE-INSTALLED
8	PARTS BAG	A100	1/2" DIA BALL VALVE PVC SCH. 40 150 PSI	-	1	
9		A100	5/8" I.D. x 10"LG TUBING - CLEAR VINYL PLAIN END	-	1	
10		A100	1-1/4" DIA RUBBER PLUG	GIST	1	
11		A100	SHIM PLASTIC	EZ - SHIM	4	
12	PUMP	-	1/2" I.D. x 2"L HOSE TAIL - CLEAR VINYL PLAIN END	JEAN TECH INC.	1	
13		-	1"x1/2" DIA ADAPTER THREADED	JEAN TECH INC.	1	
14		-	MODEL 5 - 450 GPH	JEBAO	1	

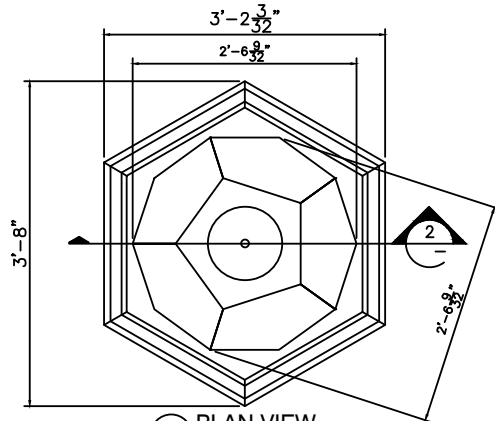


1 PLAN VIEW
SCALE: 1/2"=1'

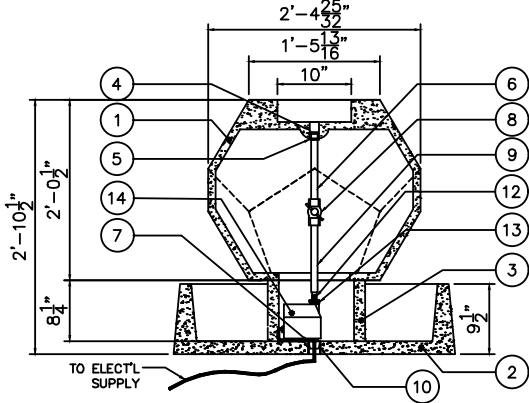

2 SECTION
SCALE: 1/2"=1'

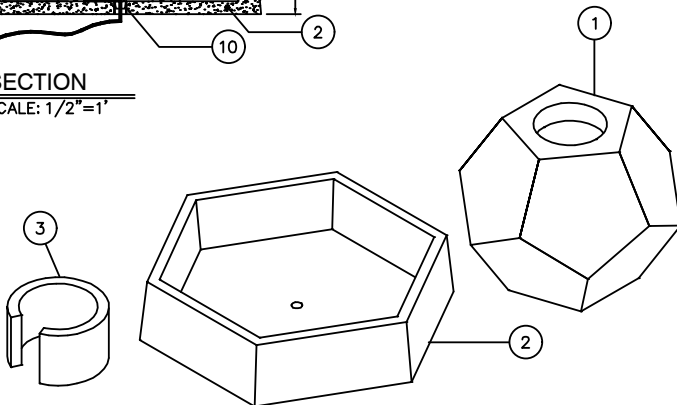


3 EXPLODED VIEW
SCALE: 1/2"=1'

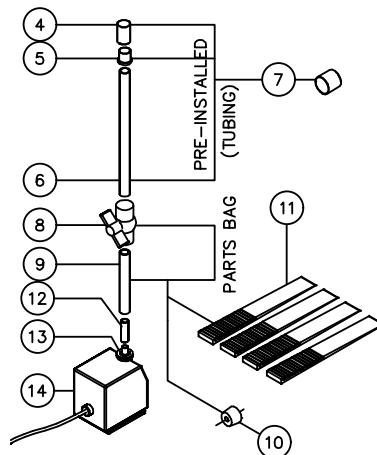

4 PIPE ASSEMBLY
SCALE: NOT TO SCALE



5 ASSEMBLY
SCALE: NOT TO SCALE

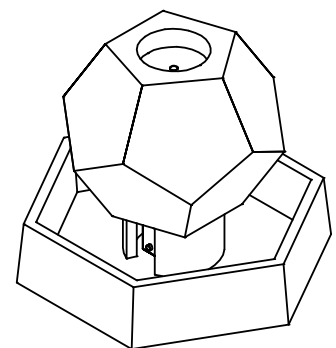

6 ASSEMBLY
SCALE: 1/2"=1'

NOTE:

Electrical supply must conform with local & national regulation/codes. If in doubt consult an electrician.
To ease connections hot water may be used to soften PVC tubing. Pump and plumbing details may vary.
Precautions should be taken to prevent damage from water freezing in reservoir.

TWELVE SIDE FOUNTAIN

PRODUCT
TWELVE SIDE
DRAWING DATE
11-16-17

DWG NO. / SKU:

TWLV

SHEET. NO. 1 OF 1

COPYRIGHT 2008 GIST DECOR 2012 GIST PRODUCTS ALL RIGHTS RESERVED



SHOP NOW