


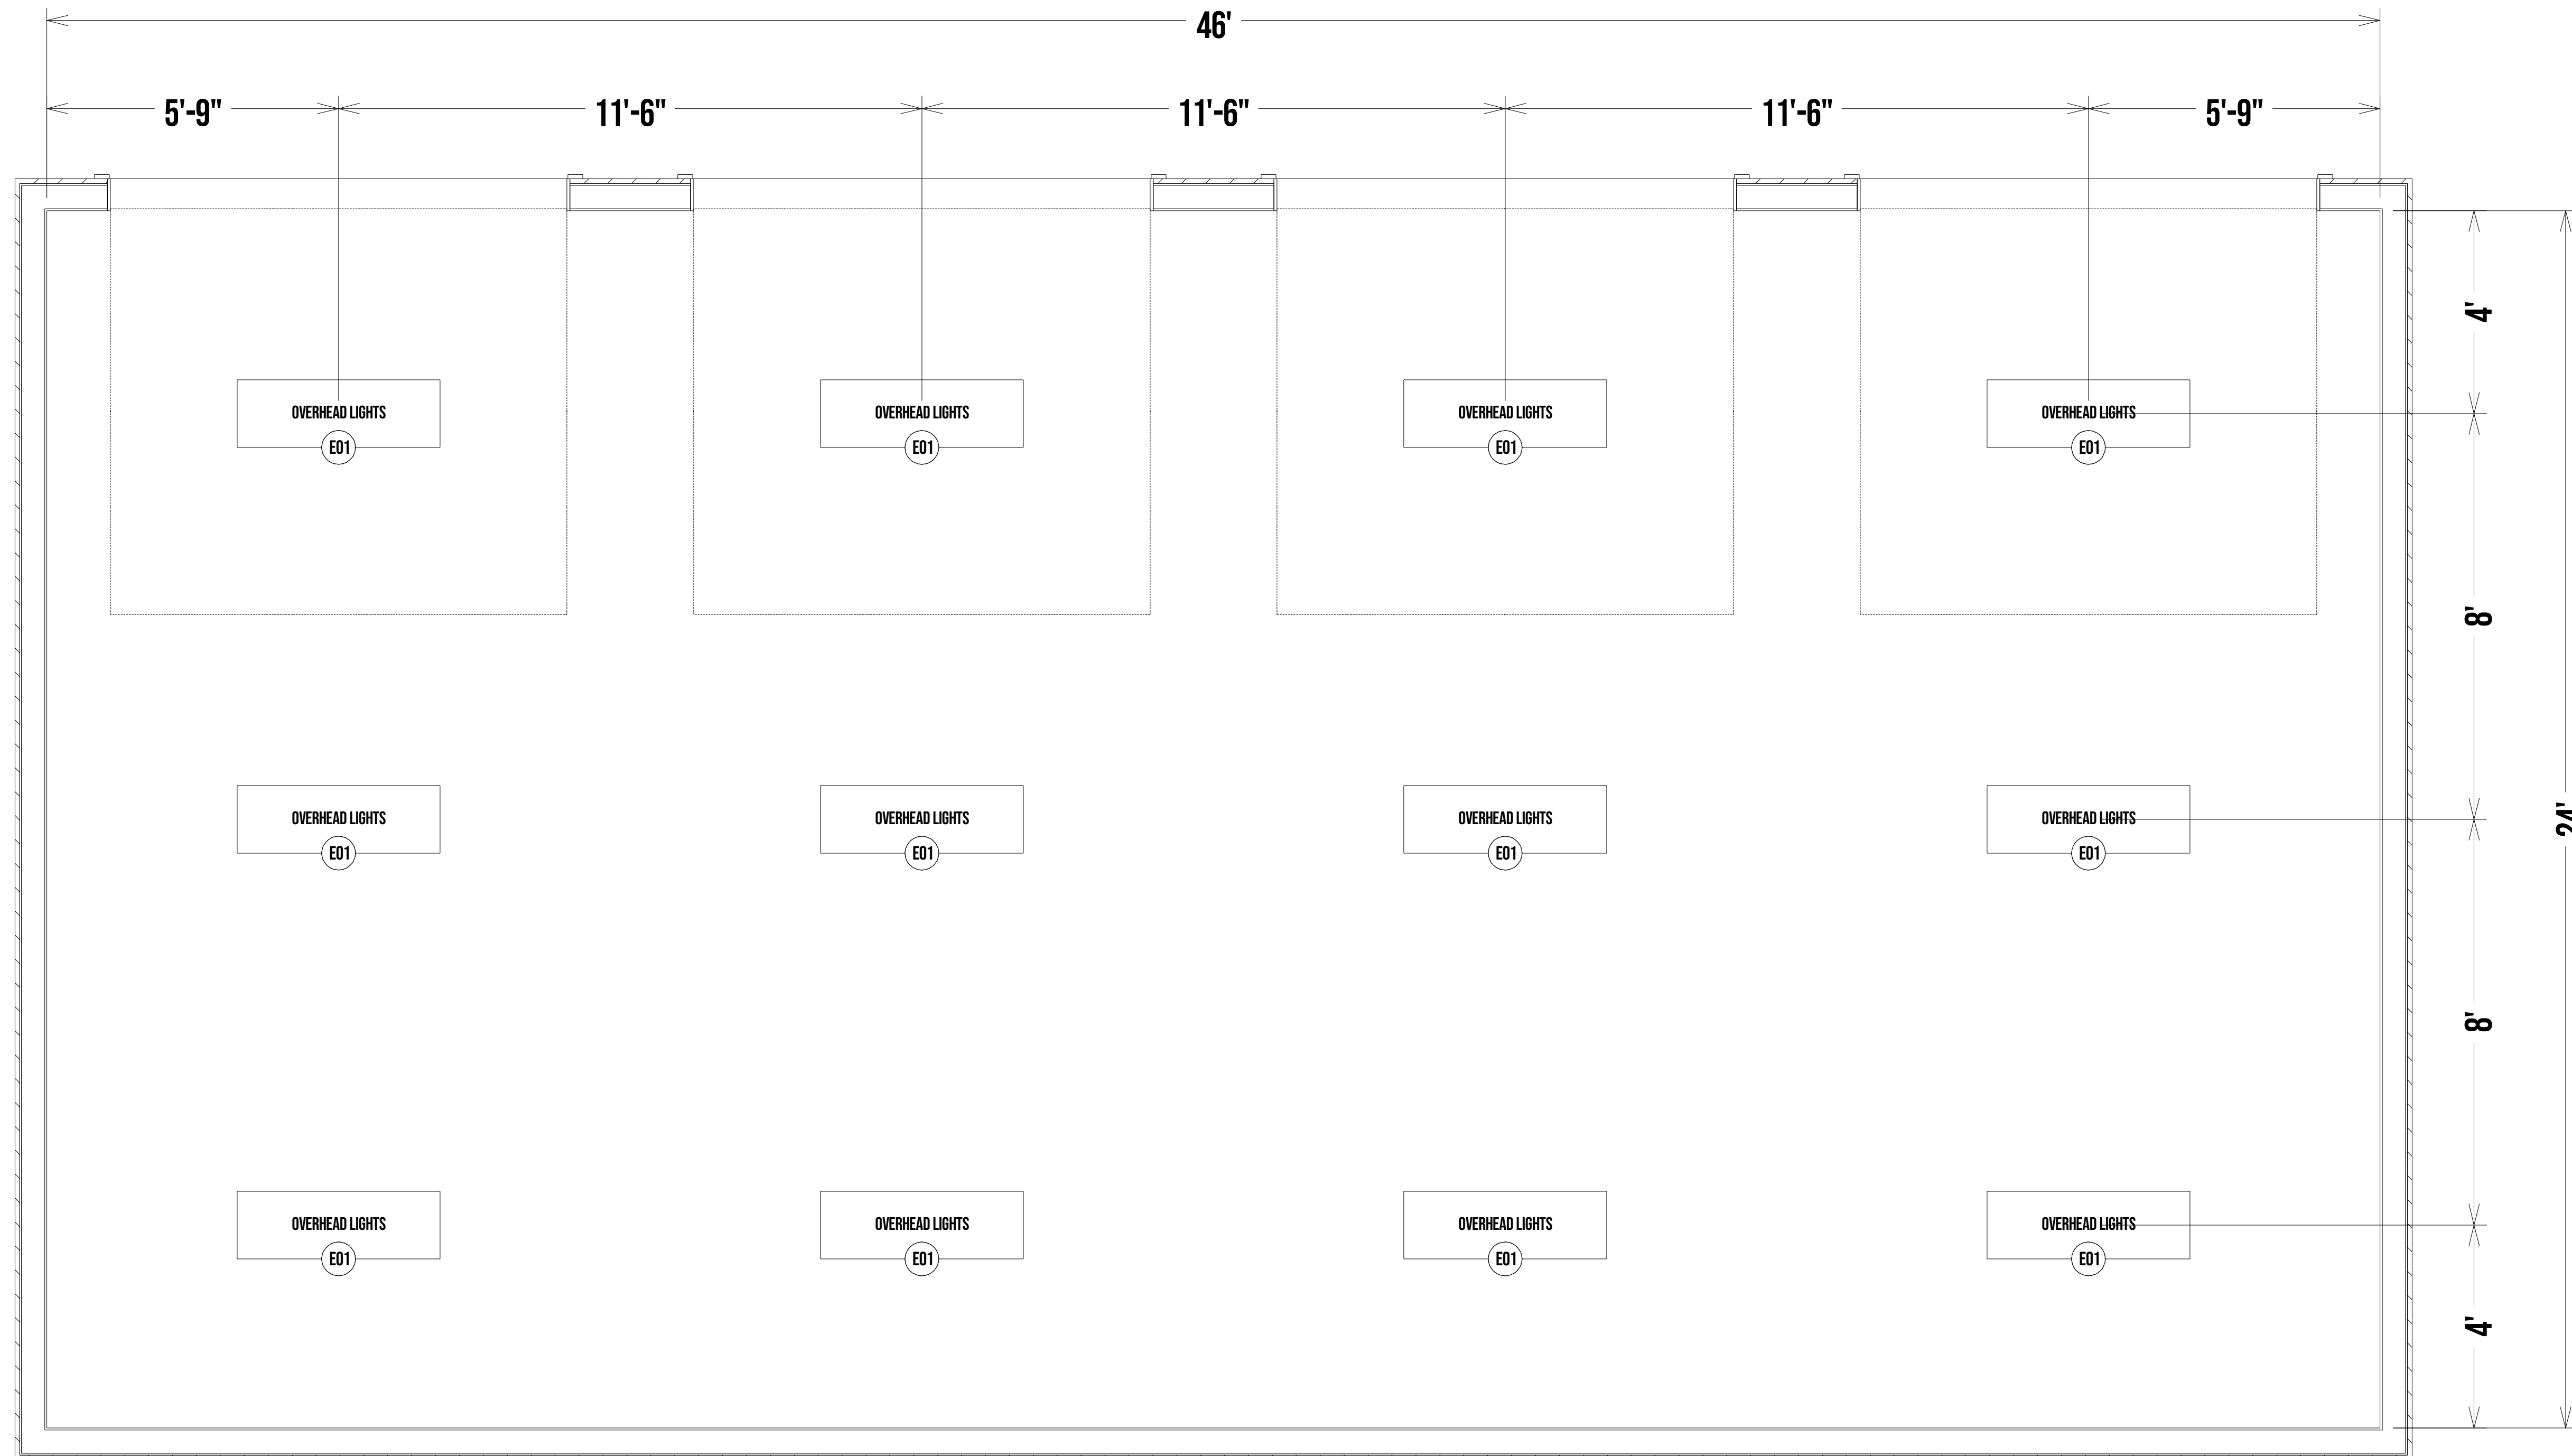

FOUR CAR GARAGE

NOTES

SCALE 1/2" = 1'-0"
SHEET
LIGHTING PLAN



LIGHTING SCHEDULE					
NUMBER	MANUFACTURER	DESCRIPTION	QTY	COMMENTS	2D SYMBOL
E01	PRIME LIGHTS	OVERHEAD LIGHTS	12		