


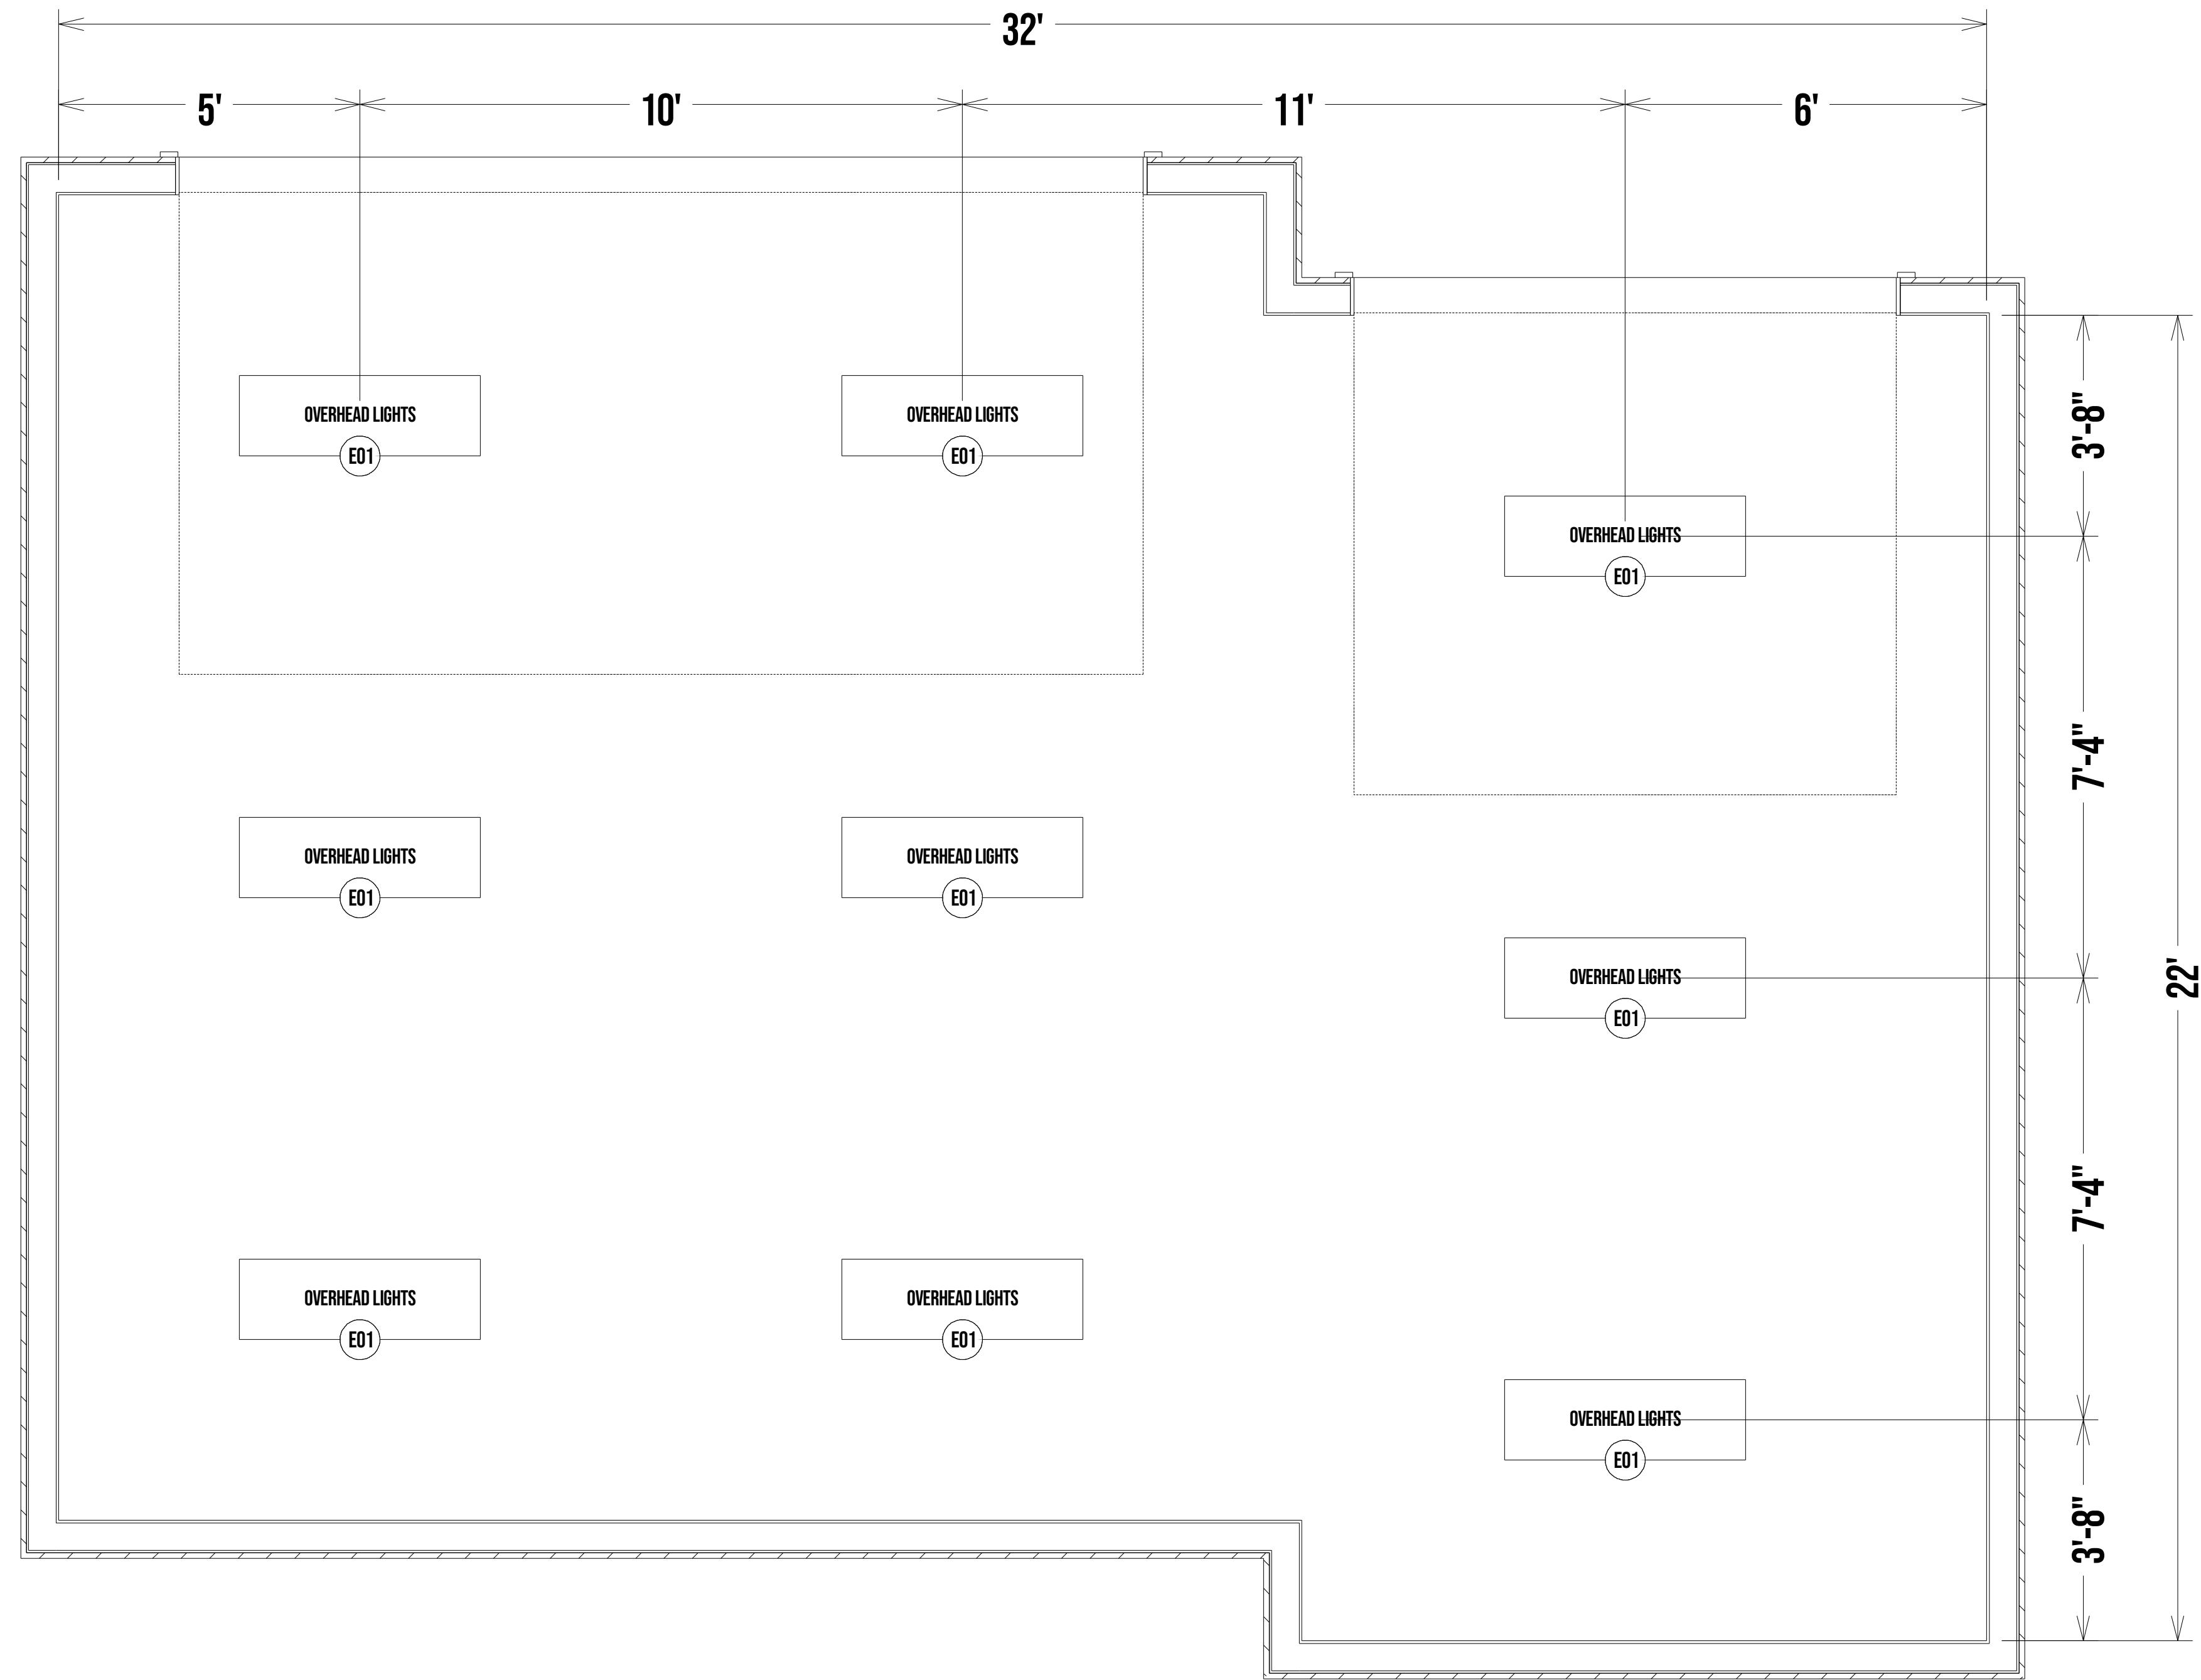

THREE CAR GARAGE



NOTES

SCALE 1/2" = 1'-0"
 SHEET
 LIGHTING PLAN

LIGHTING SCHEDULE					
NUMBER	MANUFACTURER	DESCRIPTION	QTY	COMMENTS	2D SYMBOL
E01	PRIME LIGHTS	OVERHEAD LIGHTS	9		