


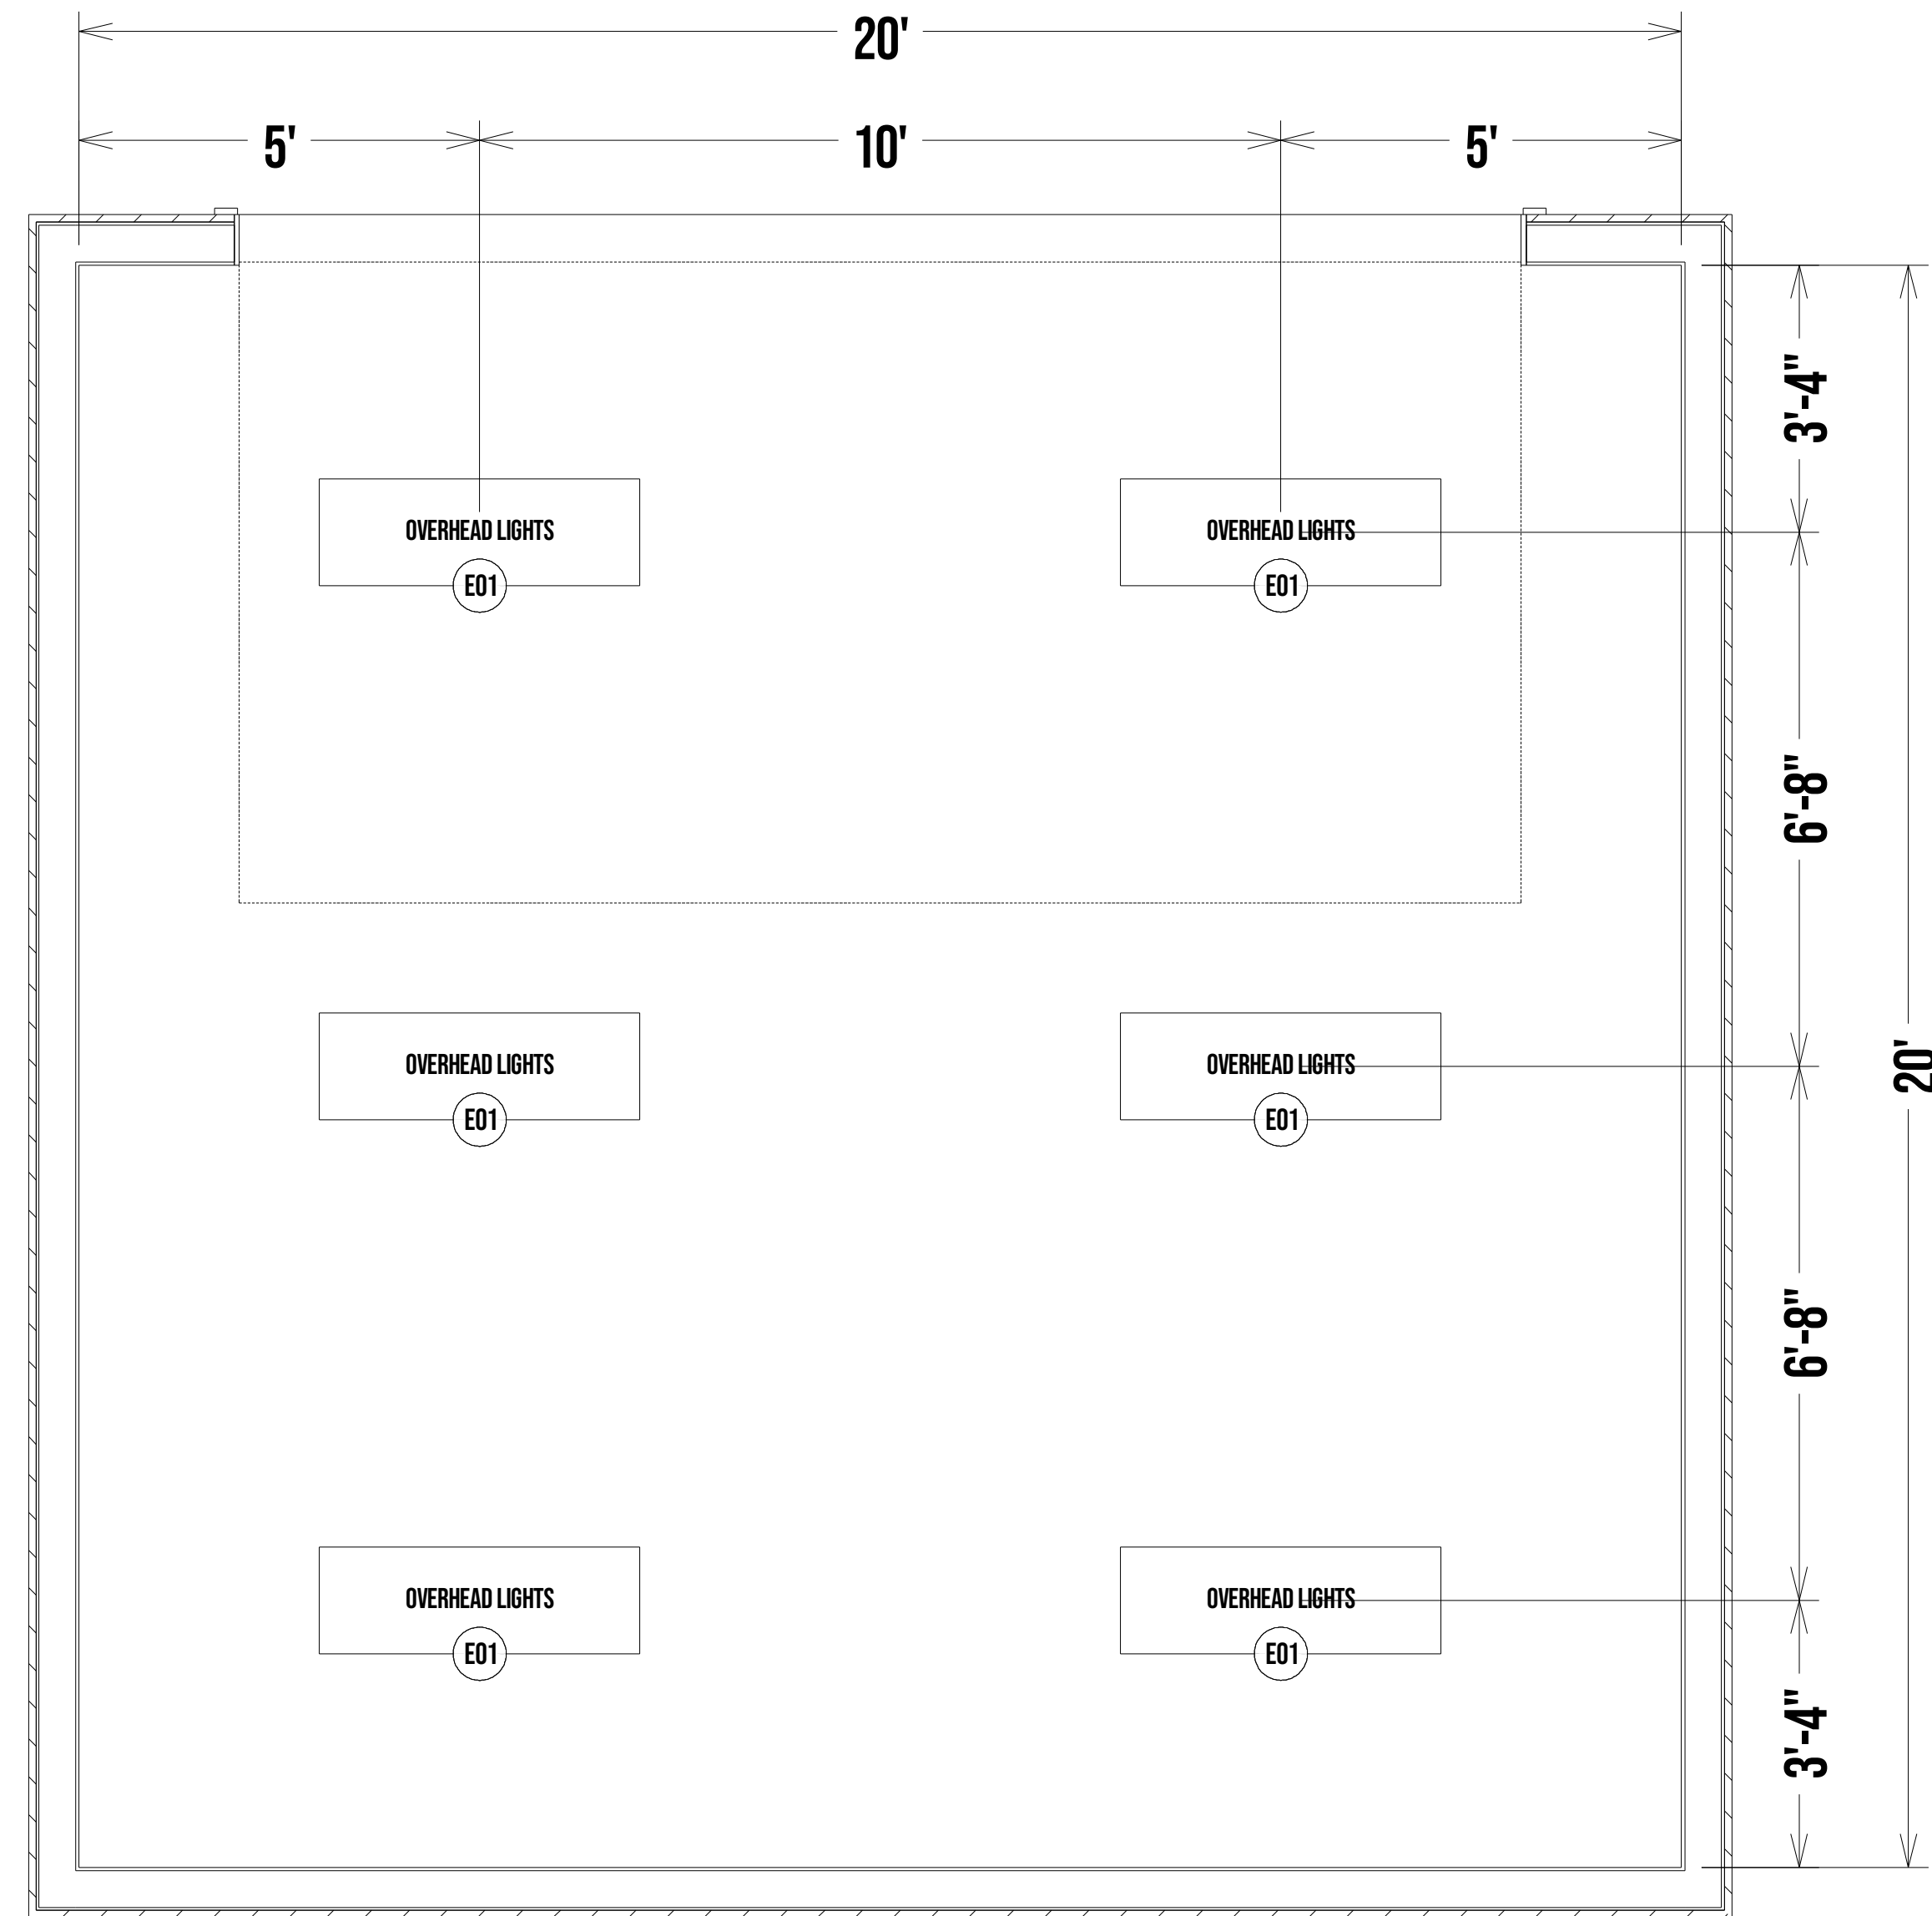

TWO CAR GARAGE



NOTES

SCALE 1/2" = 1' - 0"
 SHEET
 LIGHTING PLAN

| LIGHTING SCHEDULE | | | | | |
|-------------------|--------------|-----------------|-----|----------|-----------|
| NUMBER | MANUFACTURER | DESCRIPTION | QTY | COMMENTS | 2D SYMBOL |
| E01 | PRIME LIGHTS | OVERHEAD LIGHTS | 6 | | |