


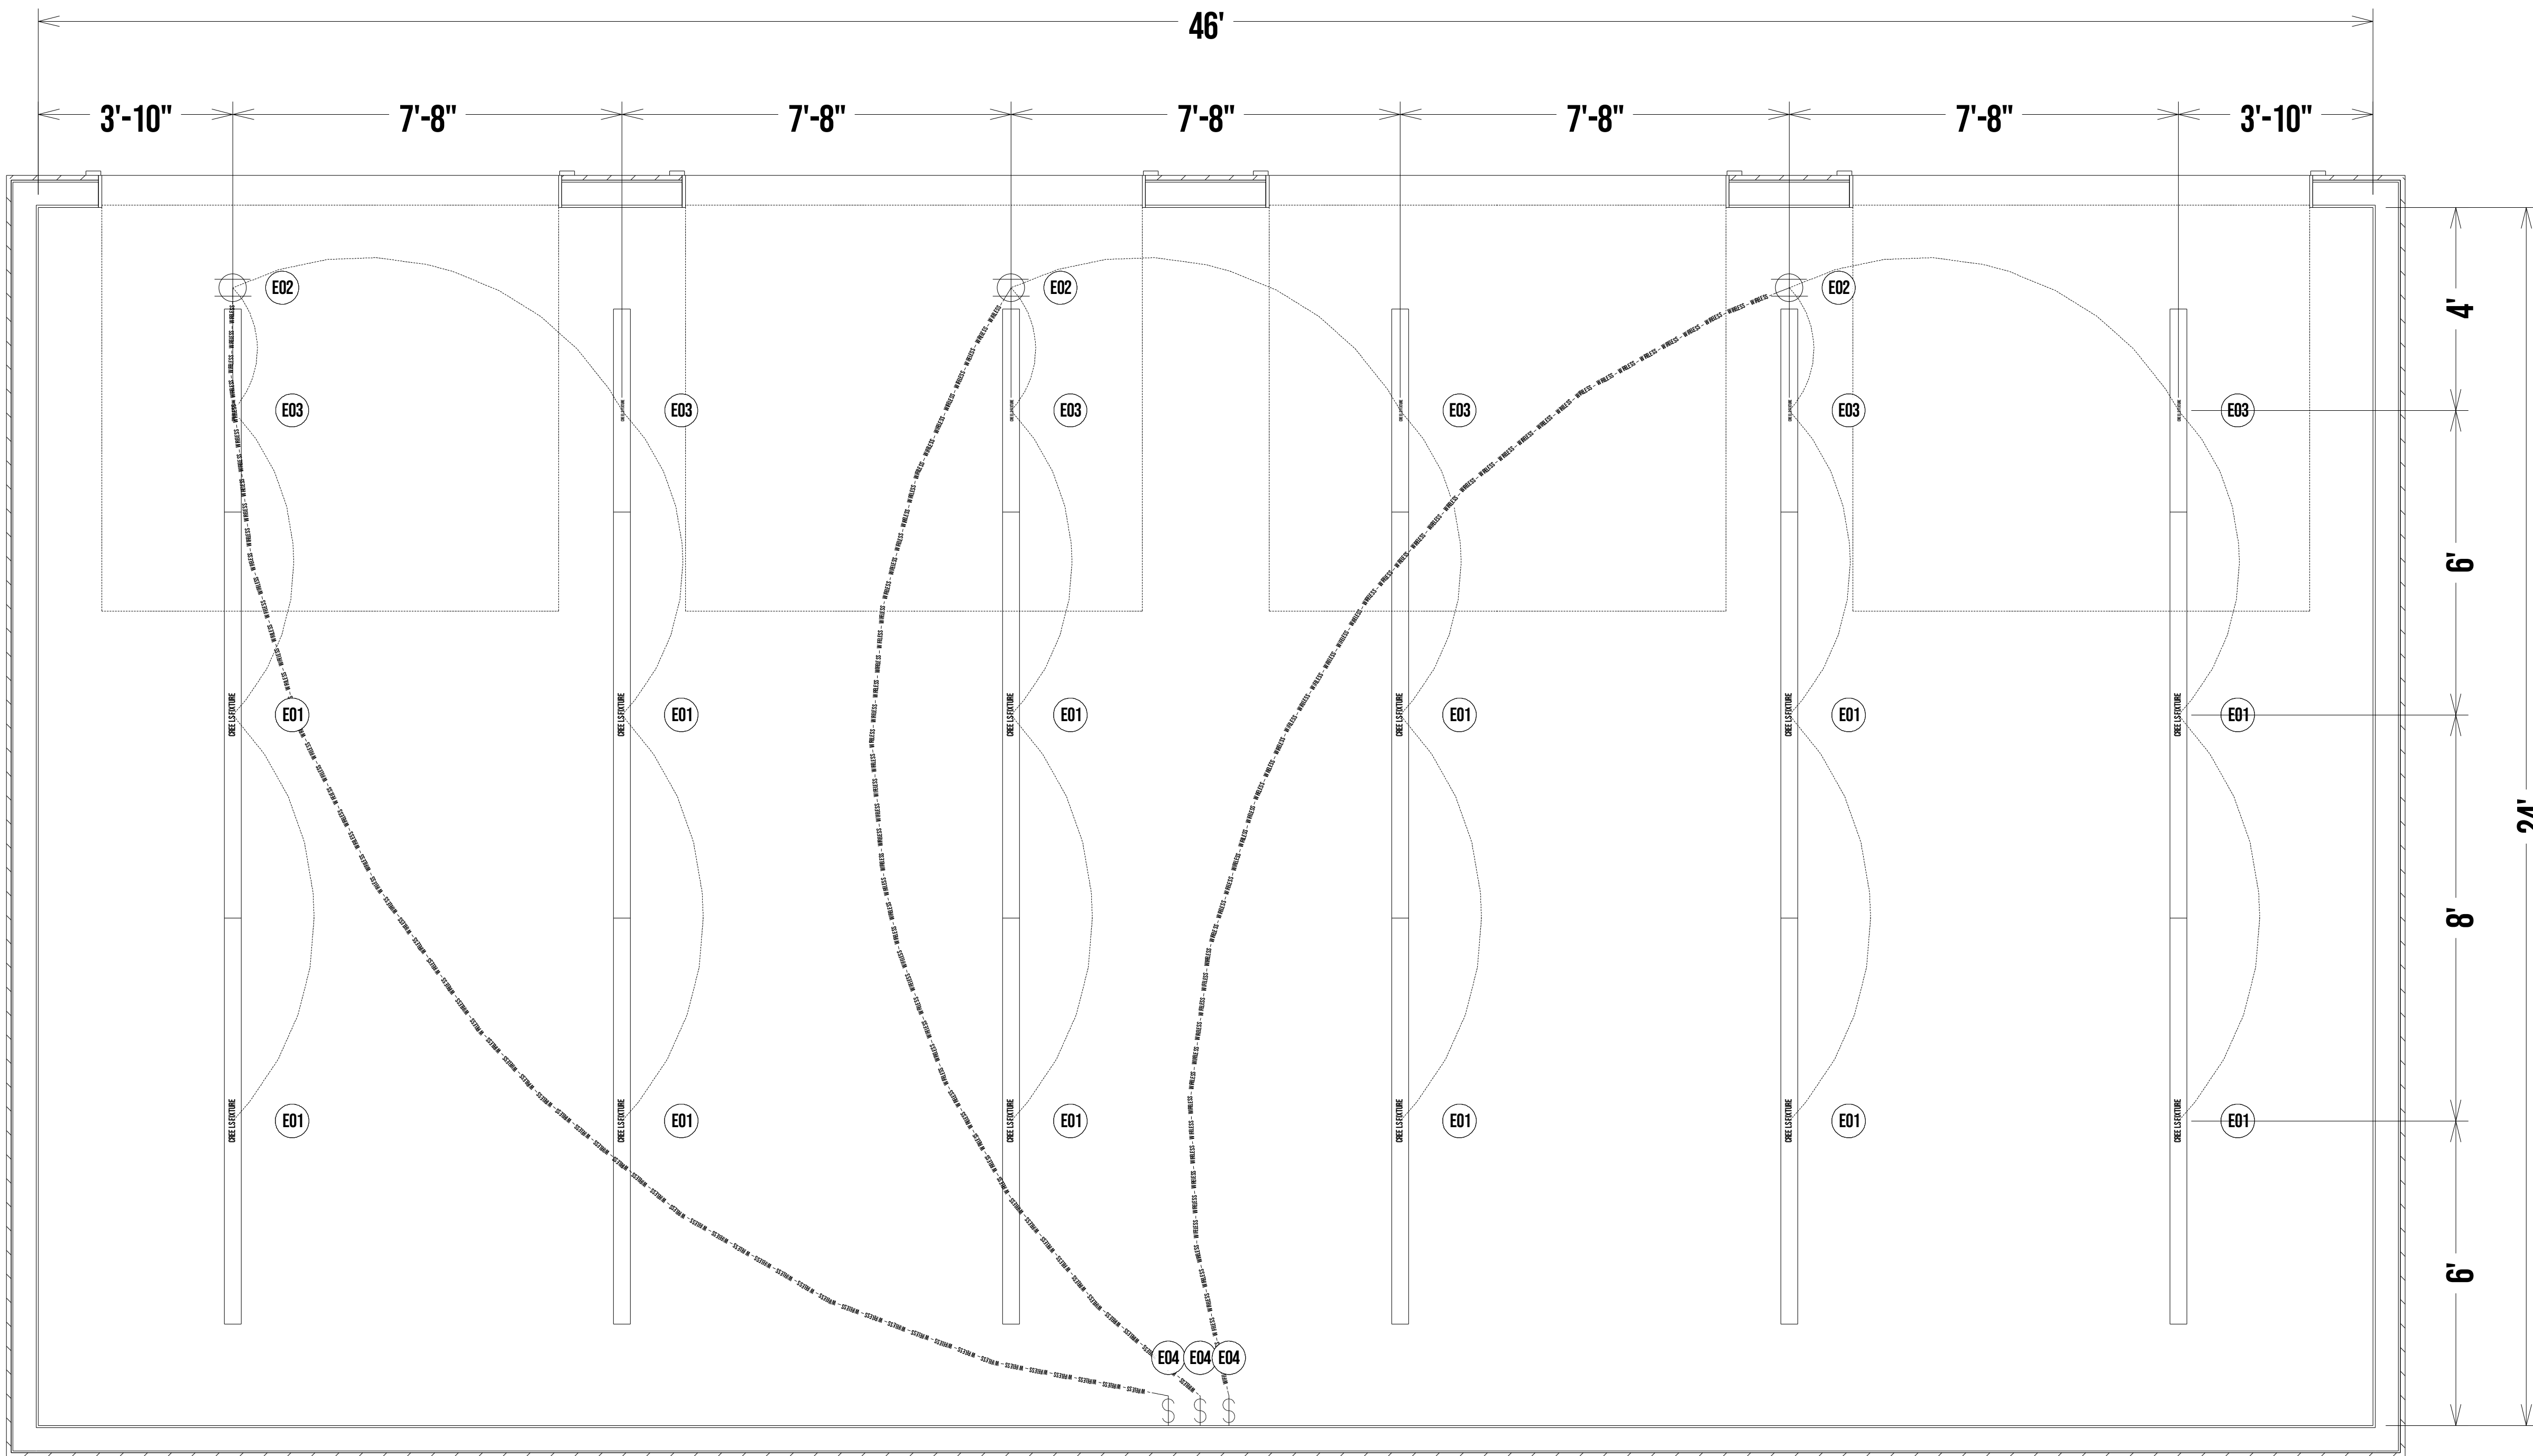

FOUR CAR GARAGE



NOTES

SCALE 1/2" = 1' - 0"
 SHEET
 LIGHTING PLAN

LIGHTING SCHEDULE					
NUMBER	MANUFACTURER	DESCRIPTION	QTY	COMMENTS	2D SYMBOL
E01	CREE LIGHTING	LS8-120L-9XX-Q-UL-10V	12		
E02	LUTRON	POWPAK	3		
E03	CREE LIGHTING	LS4-60L-9XX-Q-UL-10V	6		
E04	LUTRON	PICO WIRELESS DIMMER SWITCH	3		