


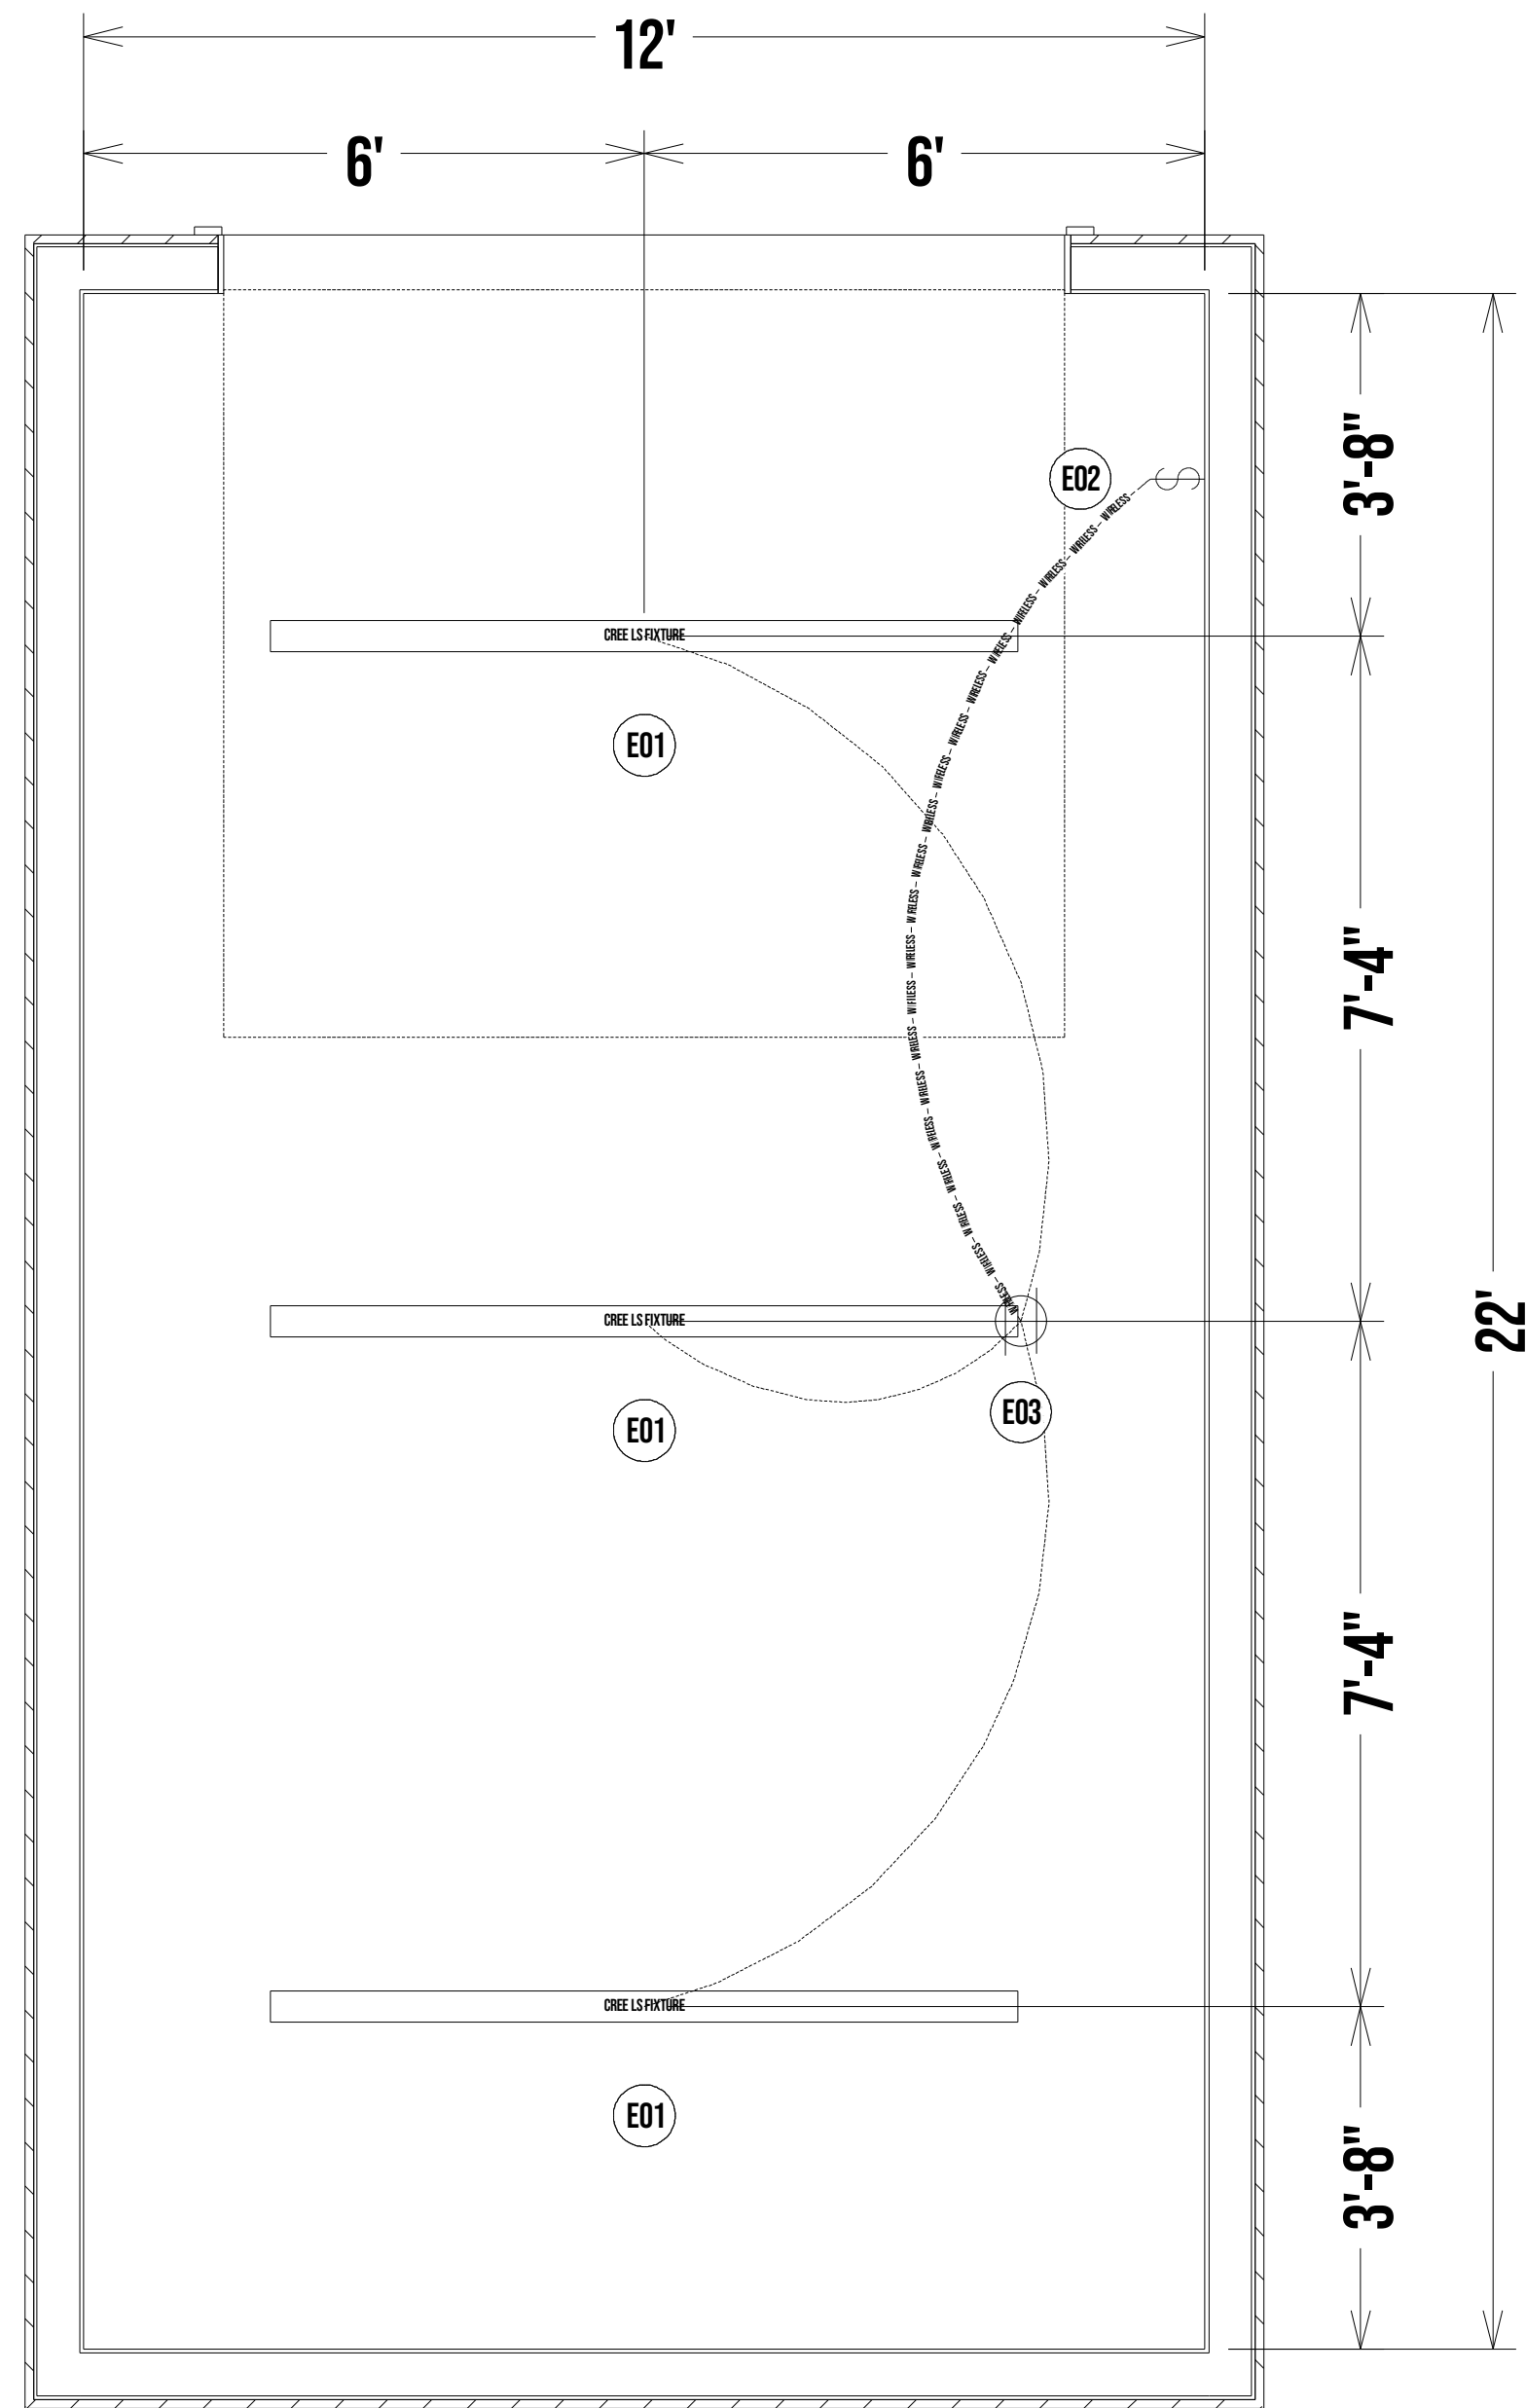

# ONE CAR GARAGE

NOTES

SCALE 1/2" = 1'-0"  
SHEET  
LIGHTING PLAN



### LIGHTING SCHEDULE

NUMBER	MANUFACTURER	DESCRIPTION	QTY	COMMENTS	2D SYMBOL
E01	CREE LIGHTING	LS8-120L-9XX-Q-UL-10V	3		
E02	LUTRON	PICO WIRELESS DIMMER SWITCH	1		
E03	LUTRON	POWPAK	1		