


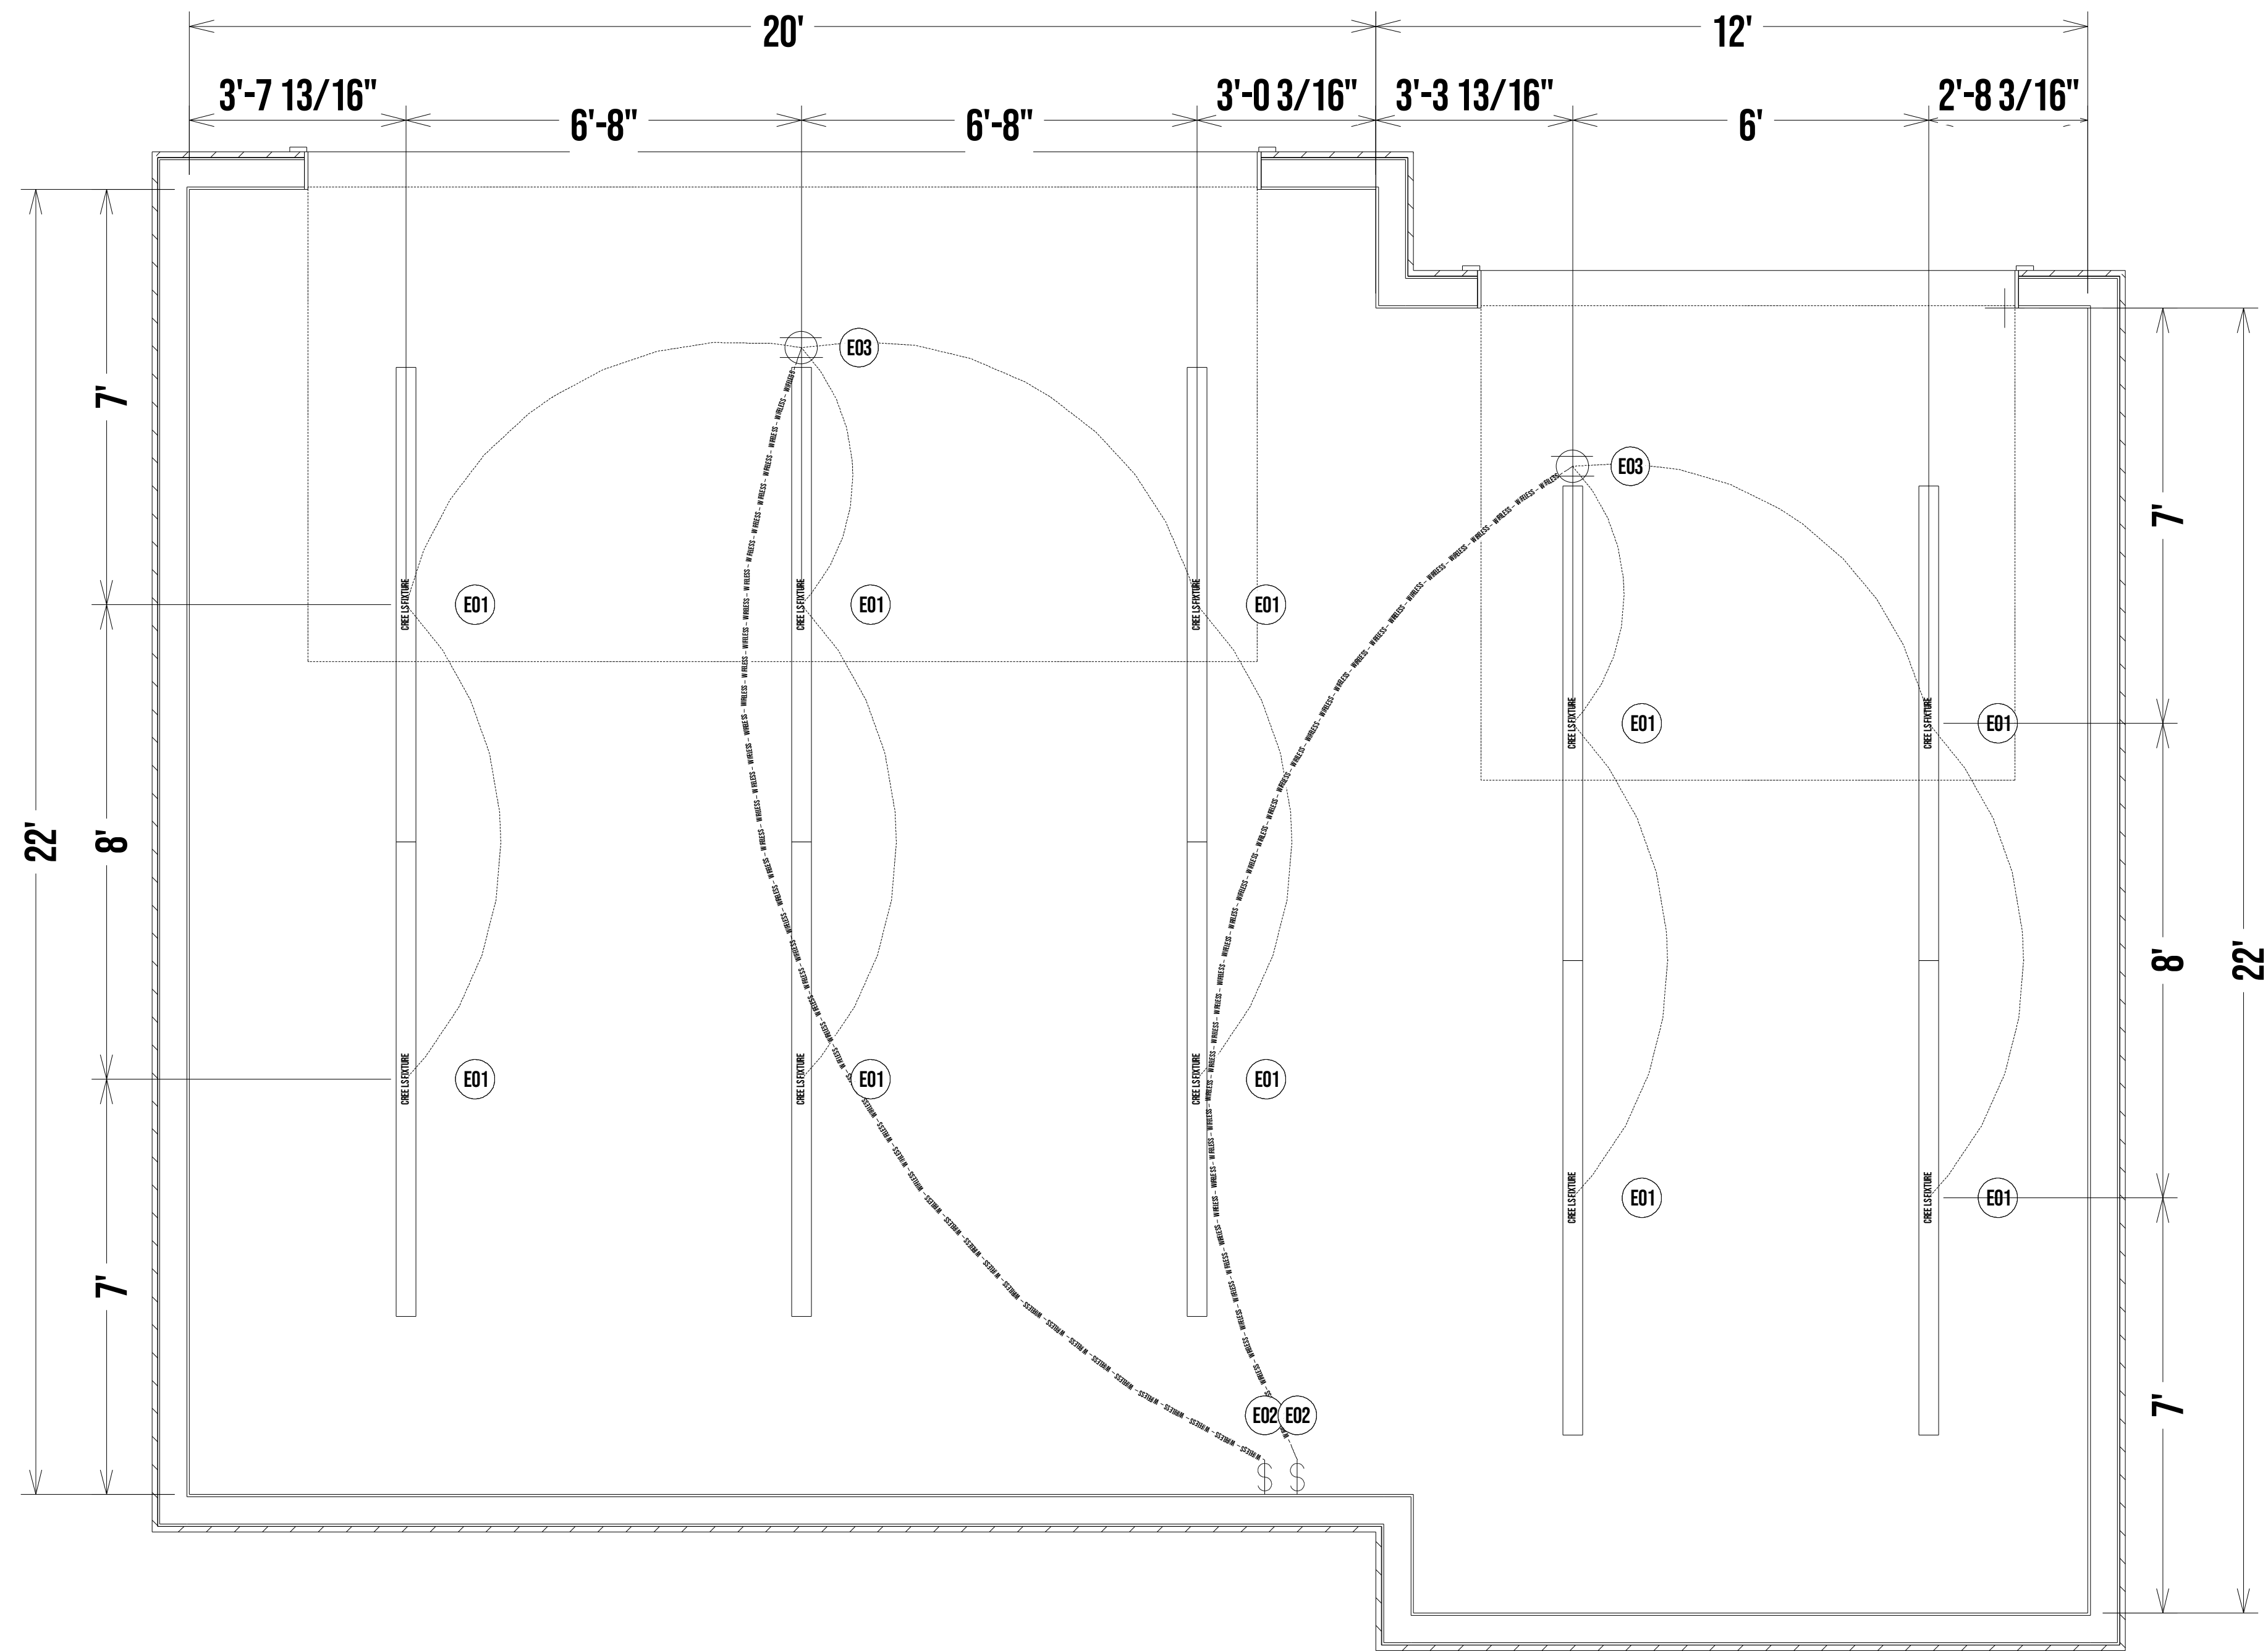

THREE CAR GARAGE



NOTES

SCALE 1/2" = 1'-0"
 SHEET
 LIGHTING PLAN

LIGHTING SCHEDULE

NUMBER	MANUFACTURER	DESCRIPTION	QTY	COMMENTS	2D SYMBOL
E01	CREE LIGHTING	LS8-120L-9XX-Q-UL-10V	10		
E02	LUTRON	PICO WIRELESS DIMMER SWITCH	2		
E03	LUTRON	POWPAK	2		